



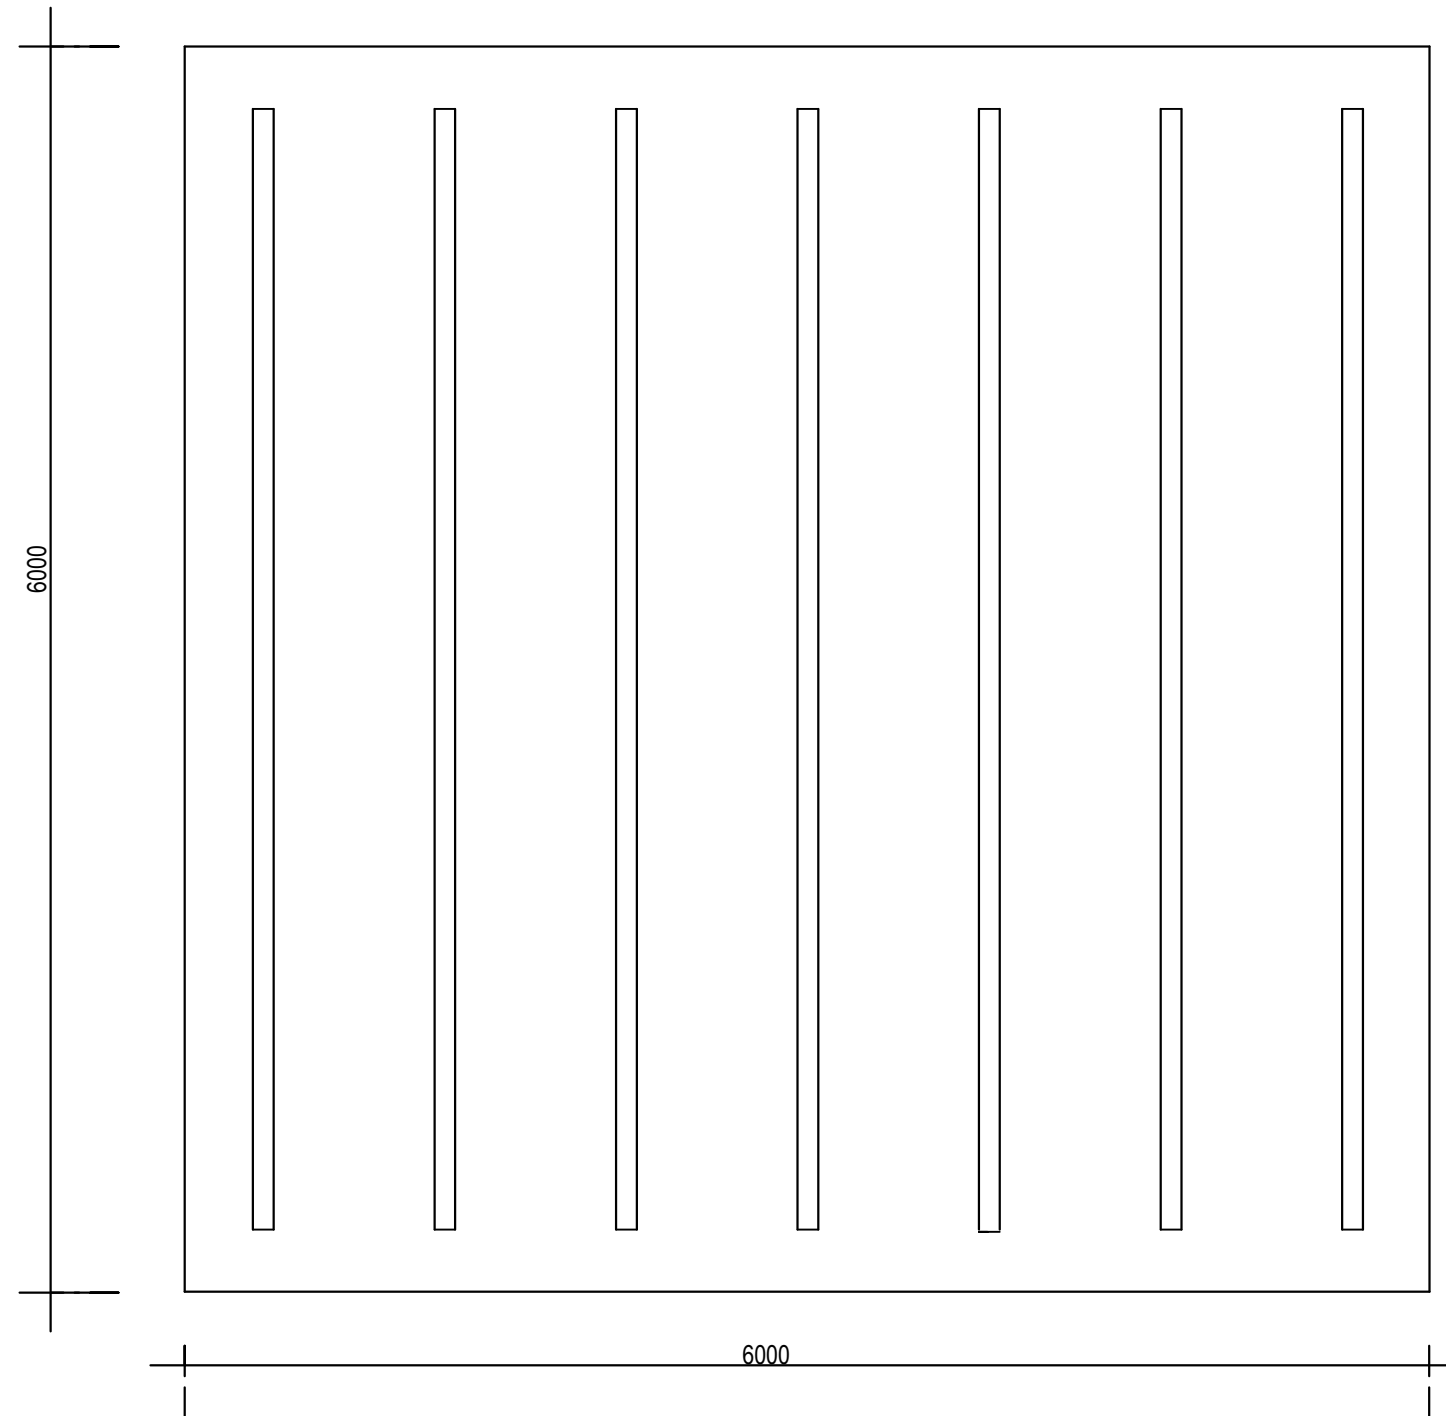


FOUNDATION PLAN

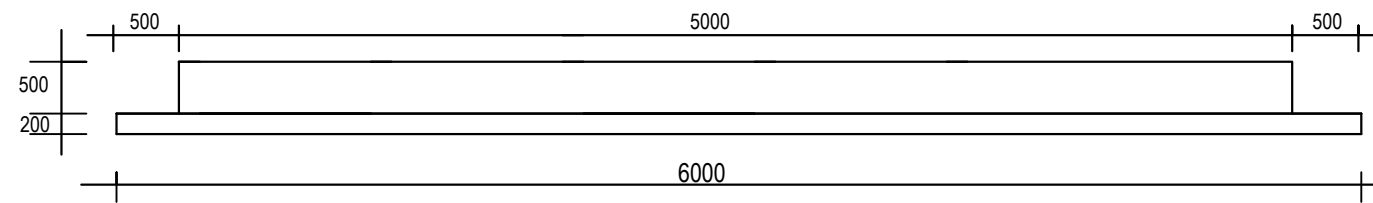



RHS & LHS VIEWS

				CLIENT:	USAID/MERCY CORPS			PROJECT	SMALL TOWN		DRAWING TITLE		Designed: Engr Soji		STAMP
				CONSULTANT	 KONSADEM ASSOCIATES LTD Engineers & Consultants 30, Onireke Layout, P.M. B. 5478, Ibadan, NIGERIA. E-mail: konsadem@gmail.com 2ML CONSULTING NIGERIA LTD Office 8, B1-Close Off 69(A) Road Gwarinpa Abuja, 			ENGINEERING DESIGN OF WASH FACILITIES ACROSS BORNO, ADAMAWA AND YOBE (BAY) STATES Service Contract No: YOL SC 14		DUMNE	DUMNE MAIN WATER SCHEME		Drawn : Damola		
SUCTION TANK 50 Cu.m)		Traced :													
TANK FOOTING PLAN		Checked : Engr Soji													
Mark : Date : Made by : Revision								STATE	ADAMAWA		DRAWING NO.	SCALE	Date : MAY 2021		Ref. No:
											AD/BD/O I				USAID/BAY/AD-00

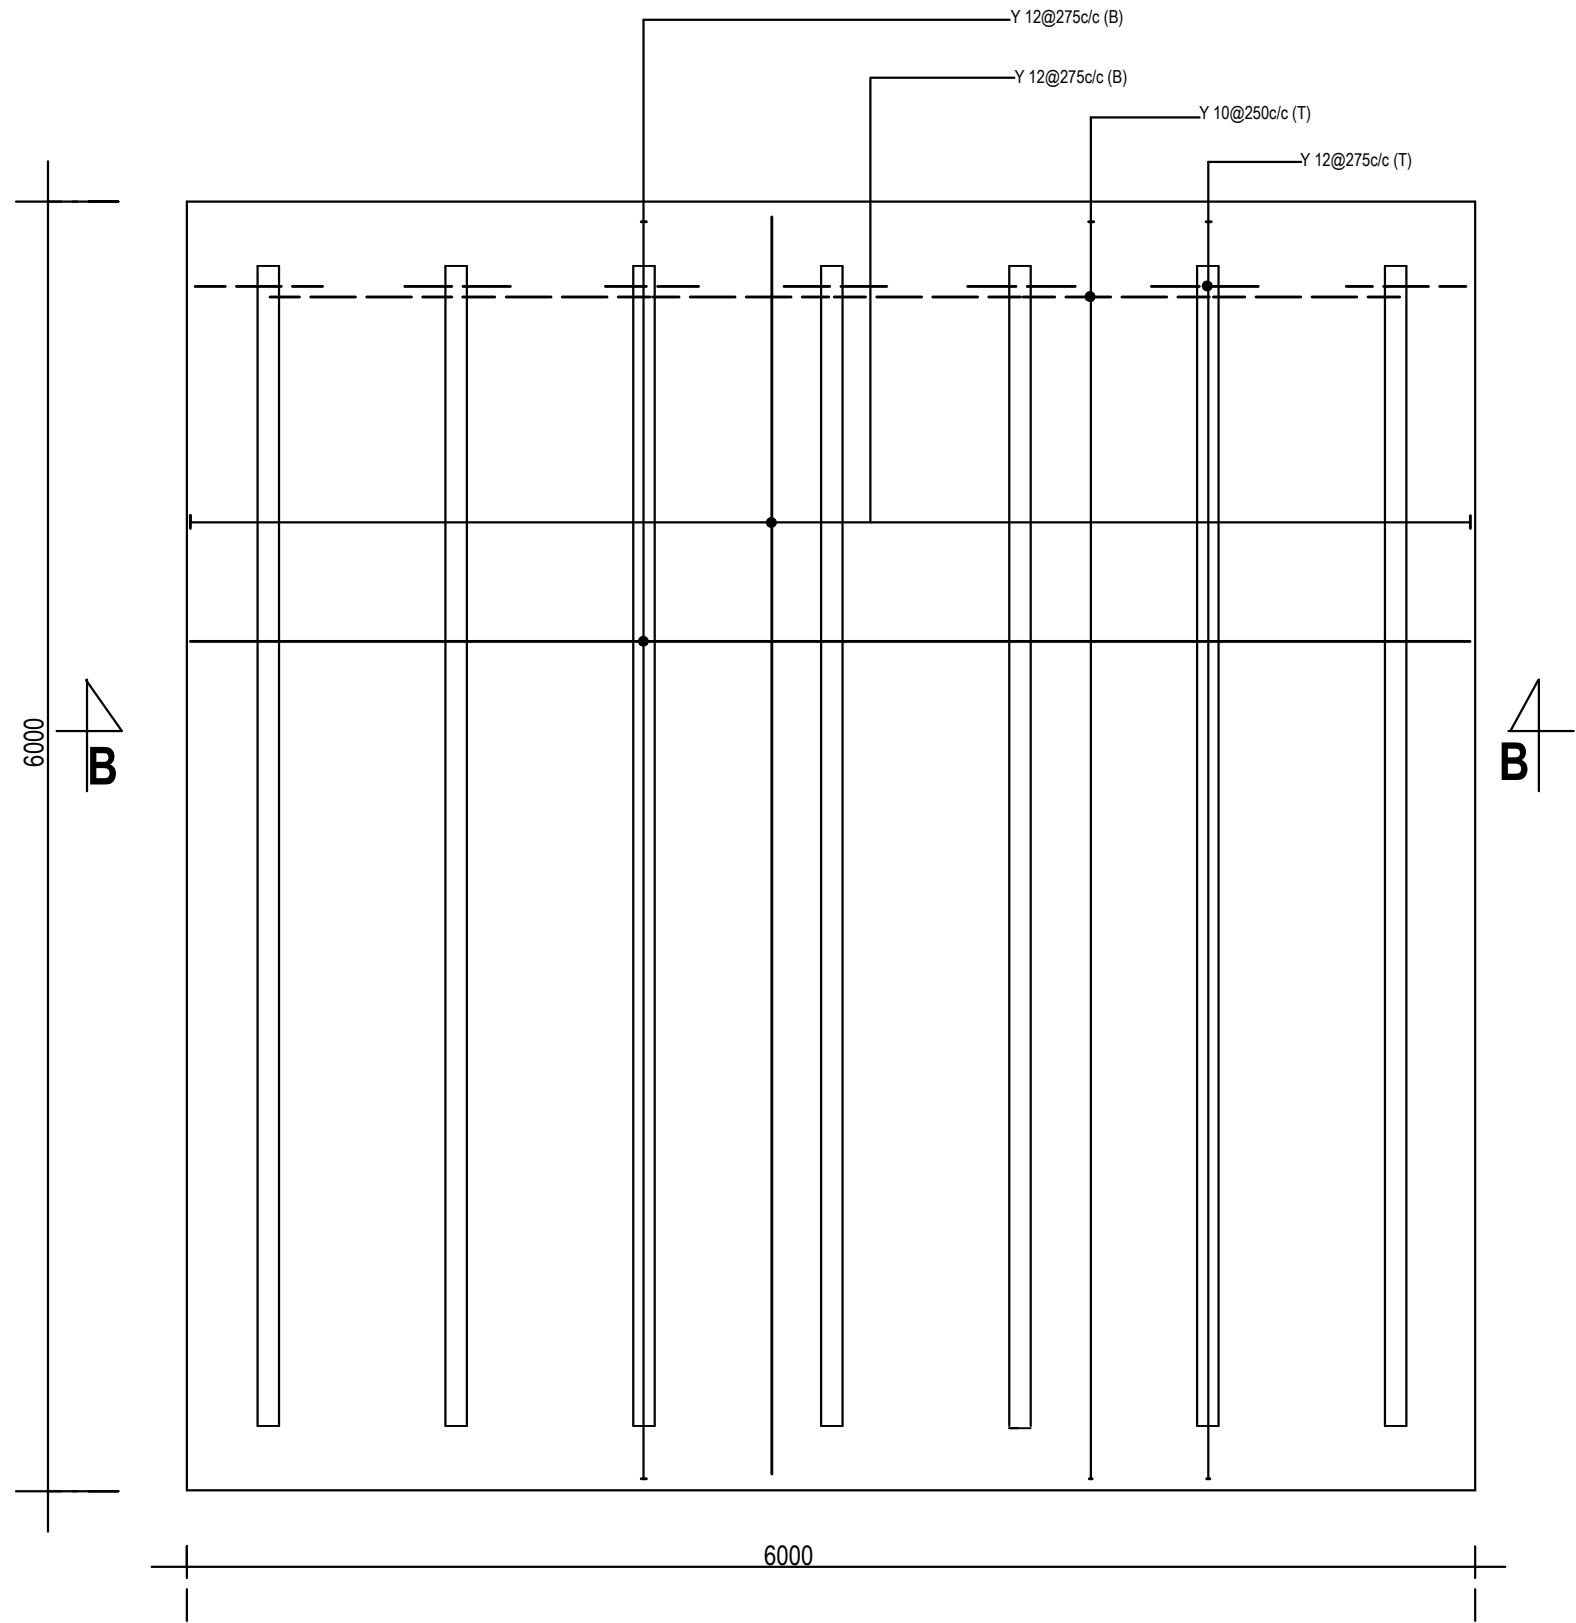


FOUNDATION DETAILS

				CLIENT:	USAID/MERCY CORPS	PROJECT	SMALL TOWN	DRAWING TITLE	Designed:	Engr Soji	STAMP
				CONSULTANT	KONSADEM ASSOCIATES LTD Engineers & Consultants 30, Onireke Layout, P.M. B. 5478, Ibadan, NIGERIA. E-mail: konsadem@gmail.com	ENGINEERING DESIGN OF WASH FACILITIES ACROSS BORNO, ADAMAWA AND YOBE (BAY) STATES Service Contract No: YOL SC 14	DUMNE	DUMNE MAIN WATER SCHEME	Drawn :	Damola	
					2ML CONSULTING NIGERIA LTD Office 8, B1-Close Off 69(A) Road Gwarinpa Abuja,	STATE		SUCTION TANK 50 Cu.m) TANK FOOTING (PLINTH) DETAILS	Traced :		
Mark :	Date :	Made by :	Revision			ADAMAWA		DRAWING NO.	Checked :	Engr Soji	
								BB/BD/O2	Date :	MAY 2021	
								SCALE	Ref. No:	USAID/BAY/BU-00	

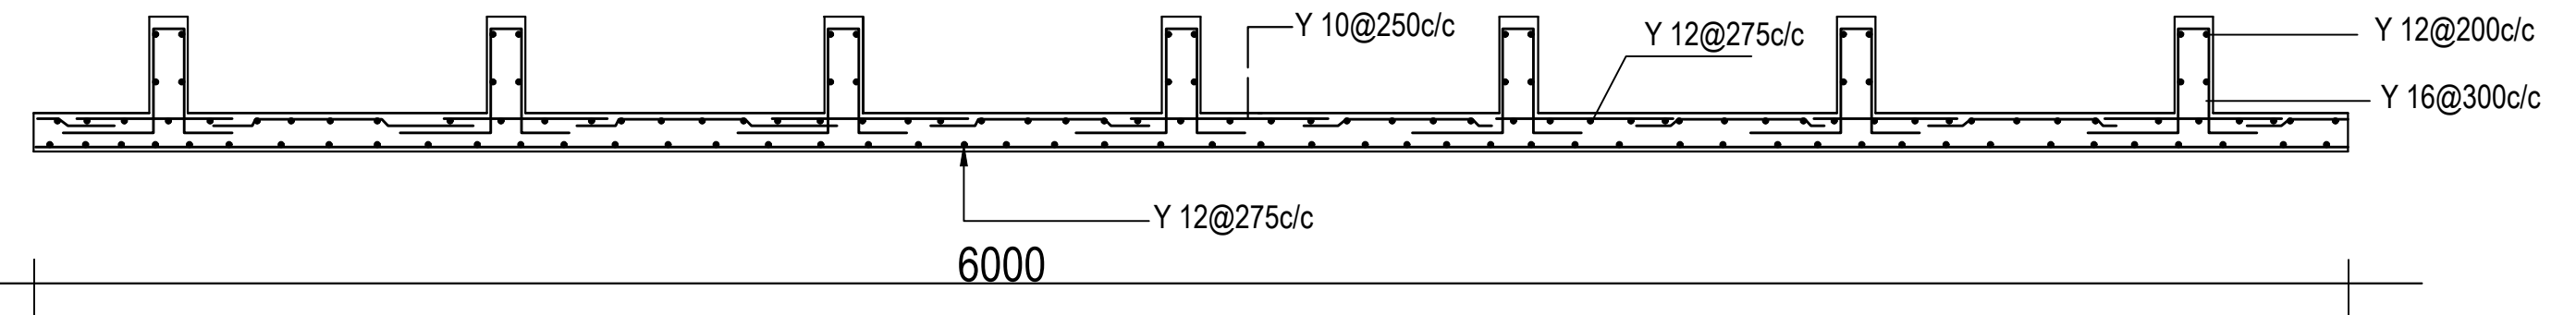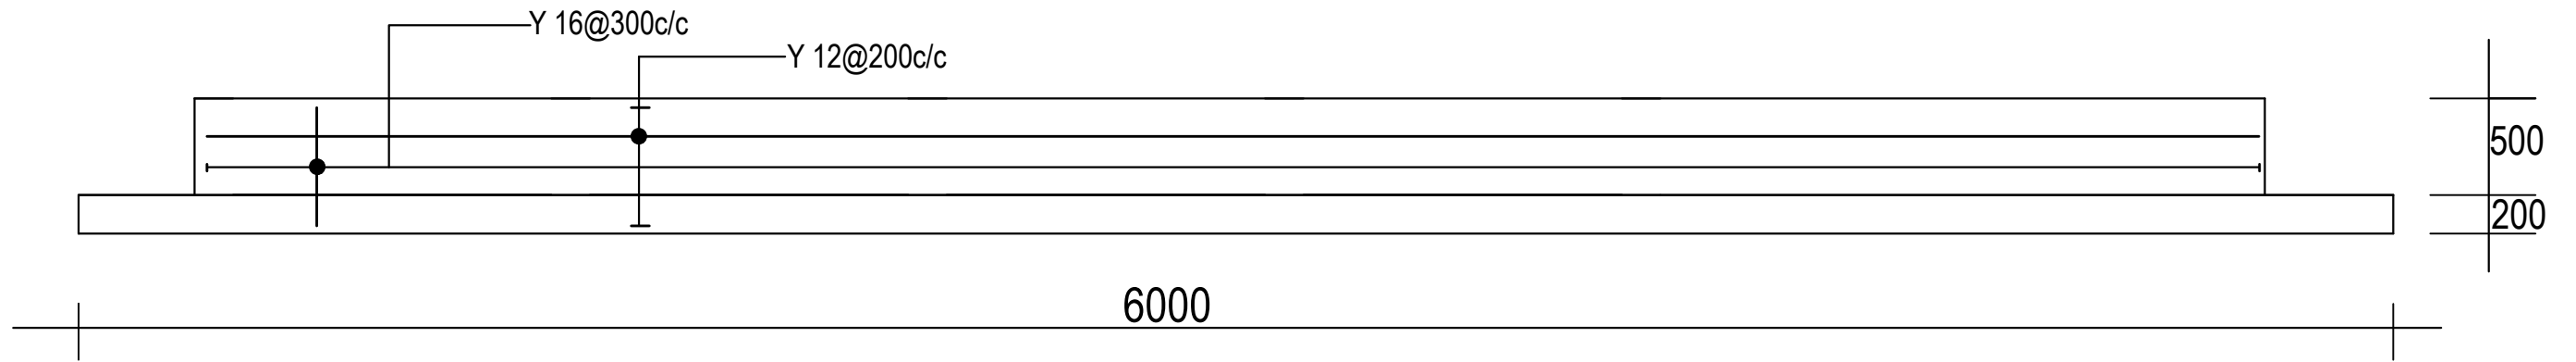


				CLIENT:	USAID/MERCY CORPS				PROJECT	SMALL TOWN		DRAWING TITLE		Designed:	Engr Soji	STAMP
				CONSULTANT	KONSADEM ASSOCIATES LTD <i>Engineers & Consultants</i> 30, Onireke Layout, P.M. B. 5478, Ibadan, NIGERIA. E-mail: konsadem@gmail.com				ENGINEERING DESIGN OF WASH FACILITIES ACROSS BORNO, ADAMAWA AND YOBE (BAY) STATES <i>Service Contract No: YOL SC 14</i>	DUMNE		SUCTION TANK 50 Cu.m) TANK FOOTING (PLINTH) DETAILS		Drawn :	Damola	
					2ML CONSULTING NIGERIA LTD Office 8, B1-Close Off 69(A) Road Gwarinpa Abuja,				STATE	ADAMAWA		DRAWING NO.		Traced :	Engr Soji	
Mark :	Date :	Made by :	Revision									SCALE		Checked :	MAY 2021	
												BB/BD/O3		Date :		Ref. No:
																USAID/BAY/BU-00

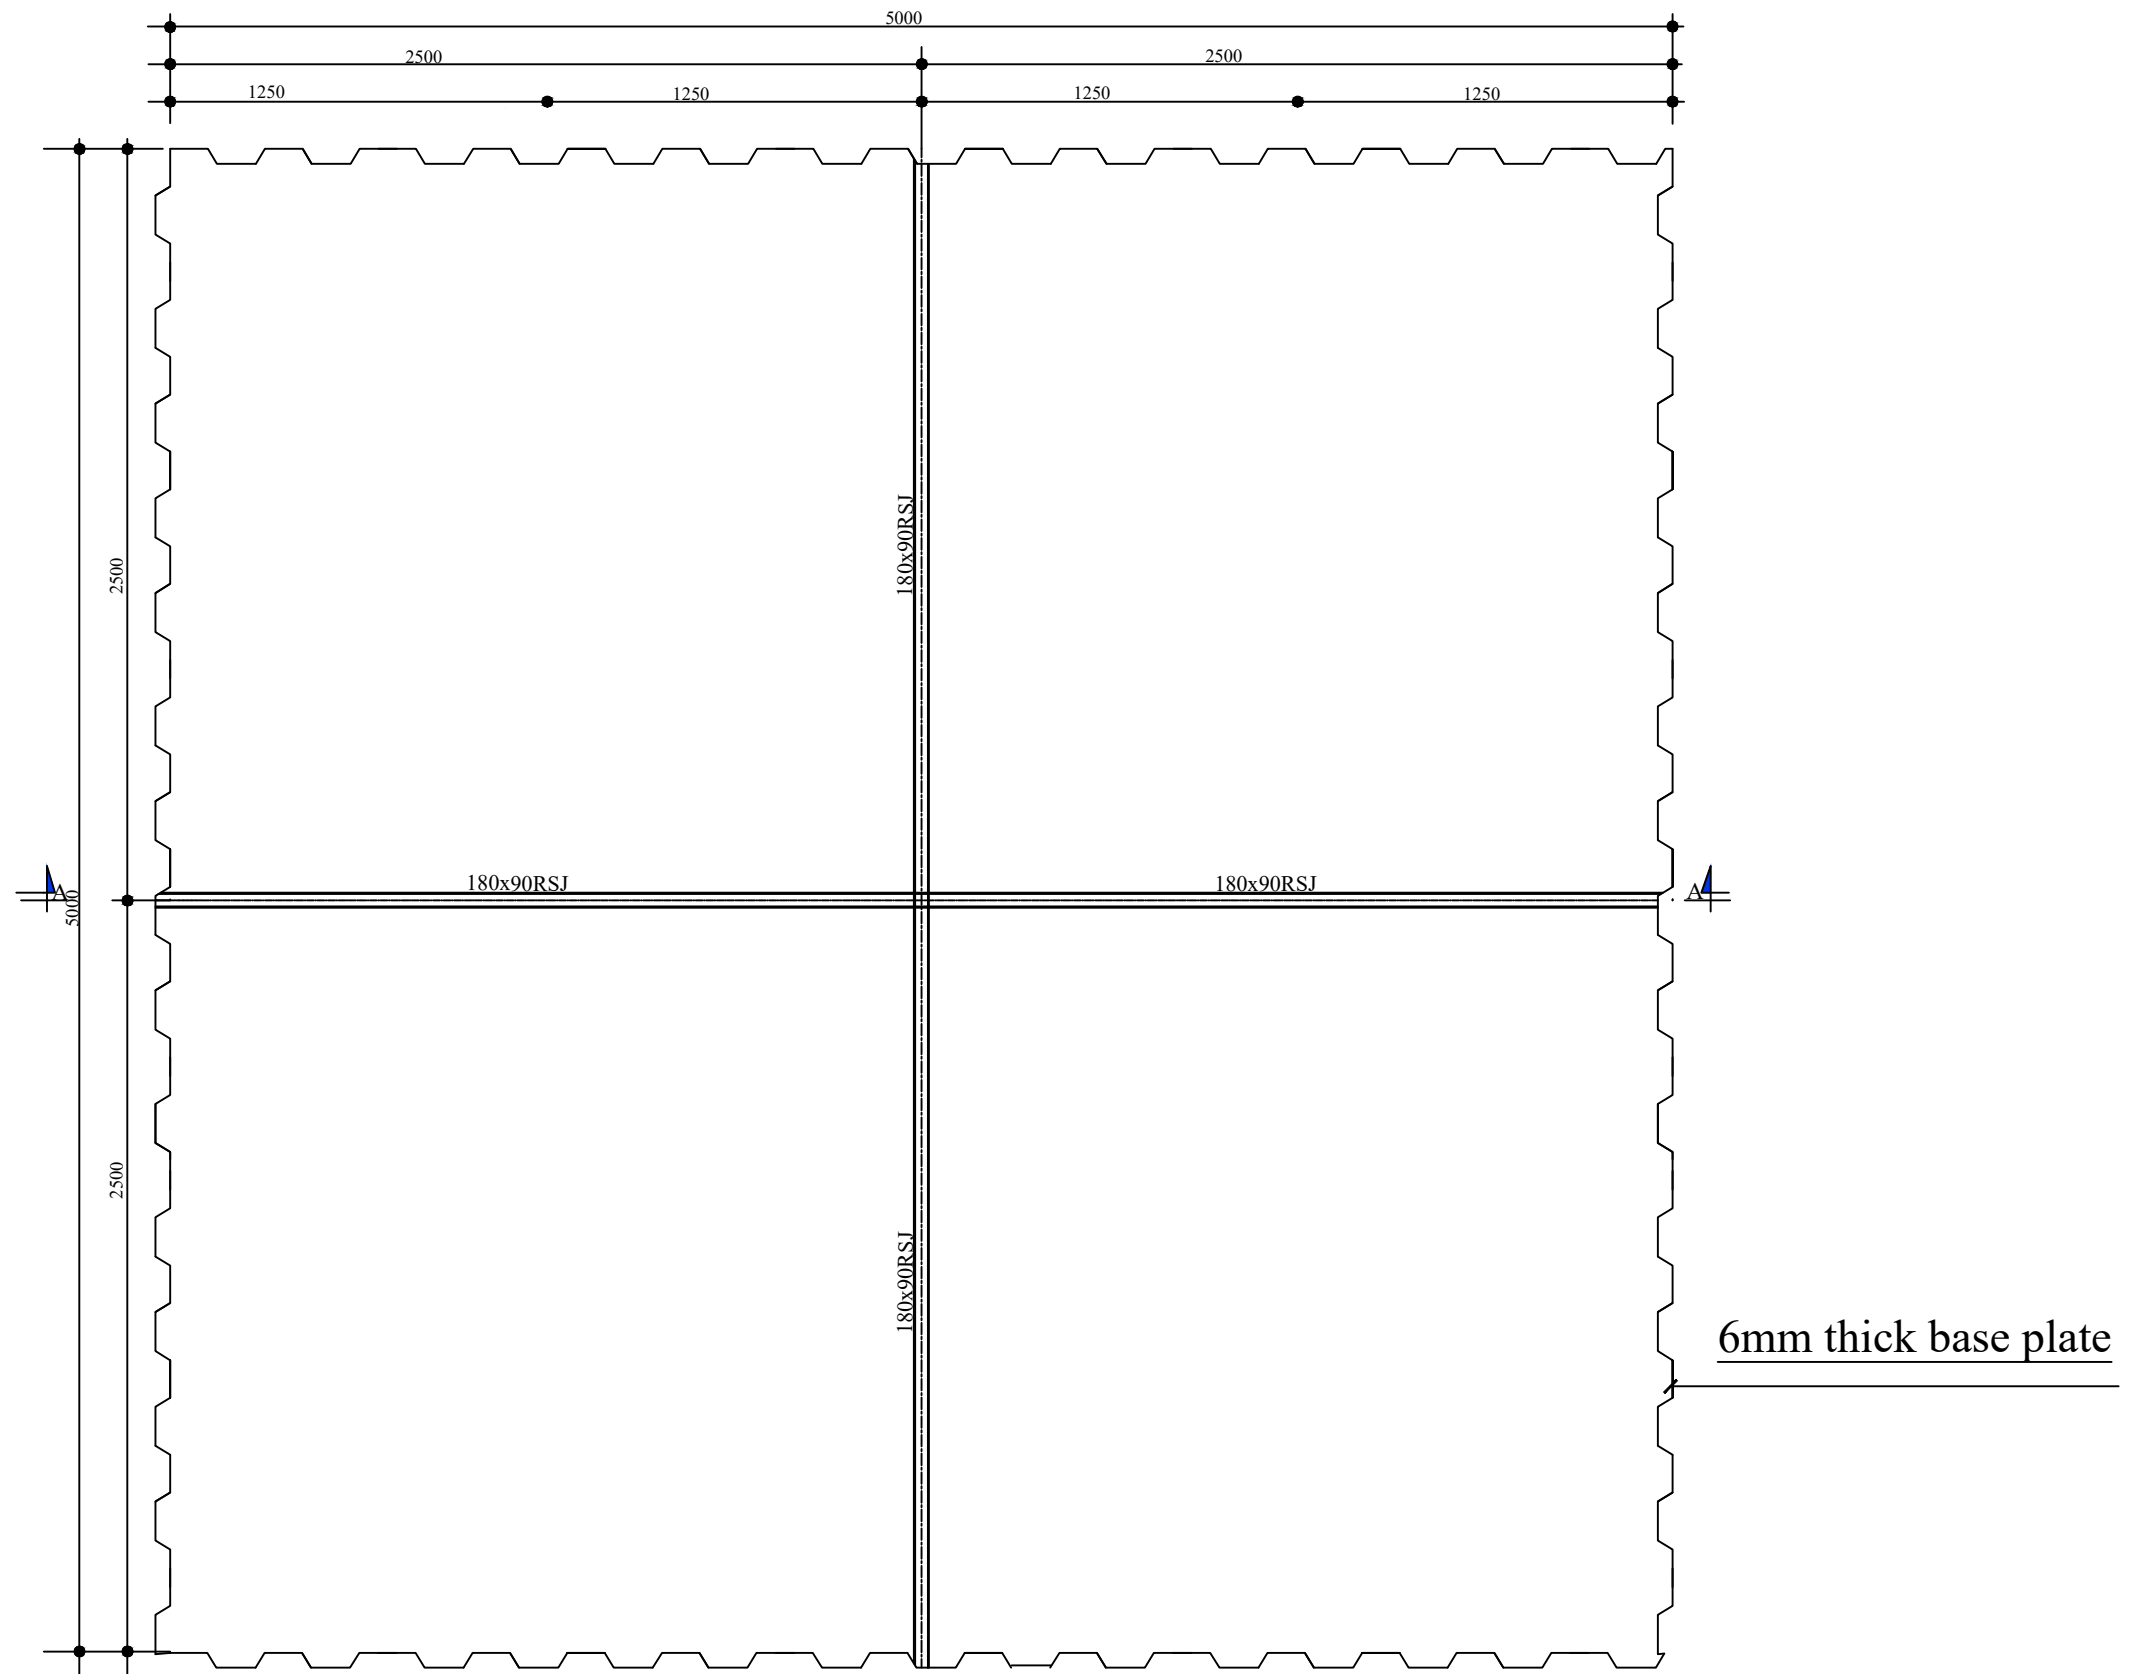





PLAN OF(GROUND TANK),50,000 LITRES (5m X 5m X 2.4m)
INTERNAL BRACES STRUCTURES

				CLIENT: USAID/MERCY CORPS	PROJECT ENGINEERING DESIGN OF WASH FACILITIES ACROSS BORNO, ADAMAWA AND YOBE (BAY) STATES Service Contract No:YOL SC 14	SMALL TOWN DUMNE	DRAWING TITLE DUMNE MAIN WATER SCHEME		Designed: Engr Soji		STAMP
							Drawn : Damola				
							Traced :				
							Checked : Engr Soji				
				CONSULTANT KONSADEM ASSOCIATES LTD Engineers & Consultants 30, Onireke Layout, P.M. B. 5478, Ibadan, NIGERIA. E-mail:konsadem@gmail.com	2ML CONSULTING NIGERIA LTD Office 8, B1-Close Off 69(A) Road Gwarinpa Abuja,		SUCTION TANK 50 Cu.m) TANK INTERNAL BRACES DETAILS		Checked : Engr Soji		Date : MAY 2021
							DATE ADAMAWA				
							DRAWING NO. BB/BD/04				
							SCALE				
Mark : Date : Made by : Revision							Ref. No: USAID/BAY/BU-00				

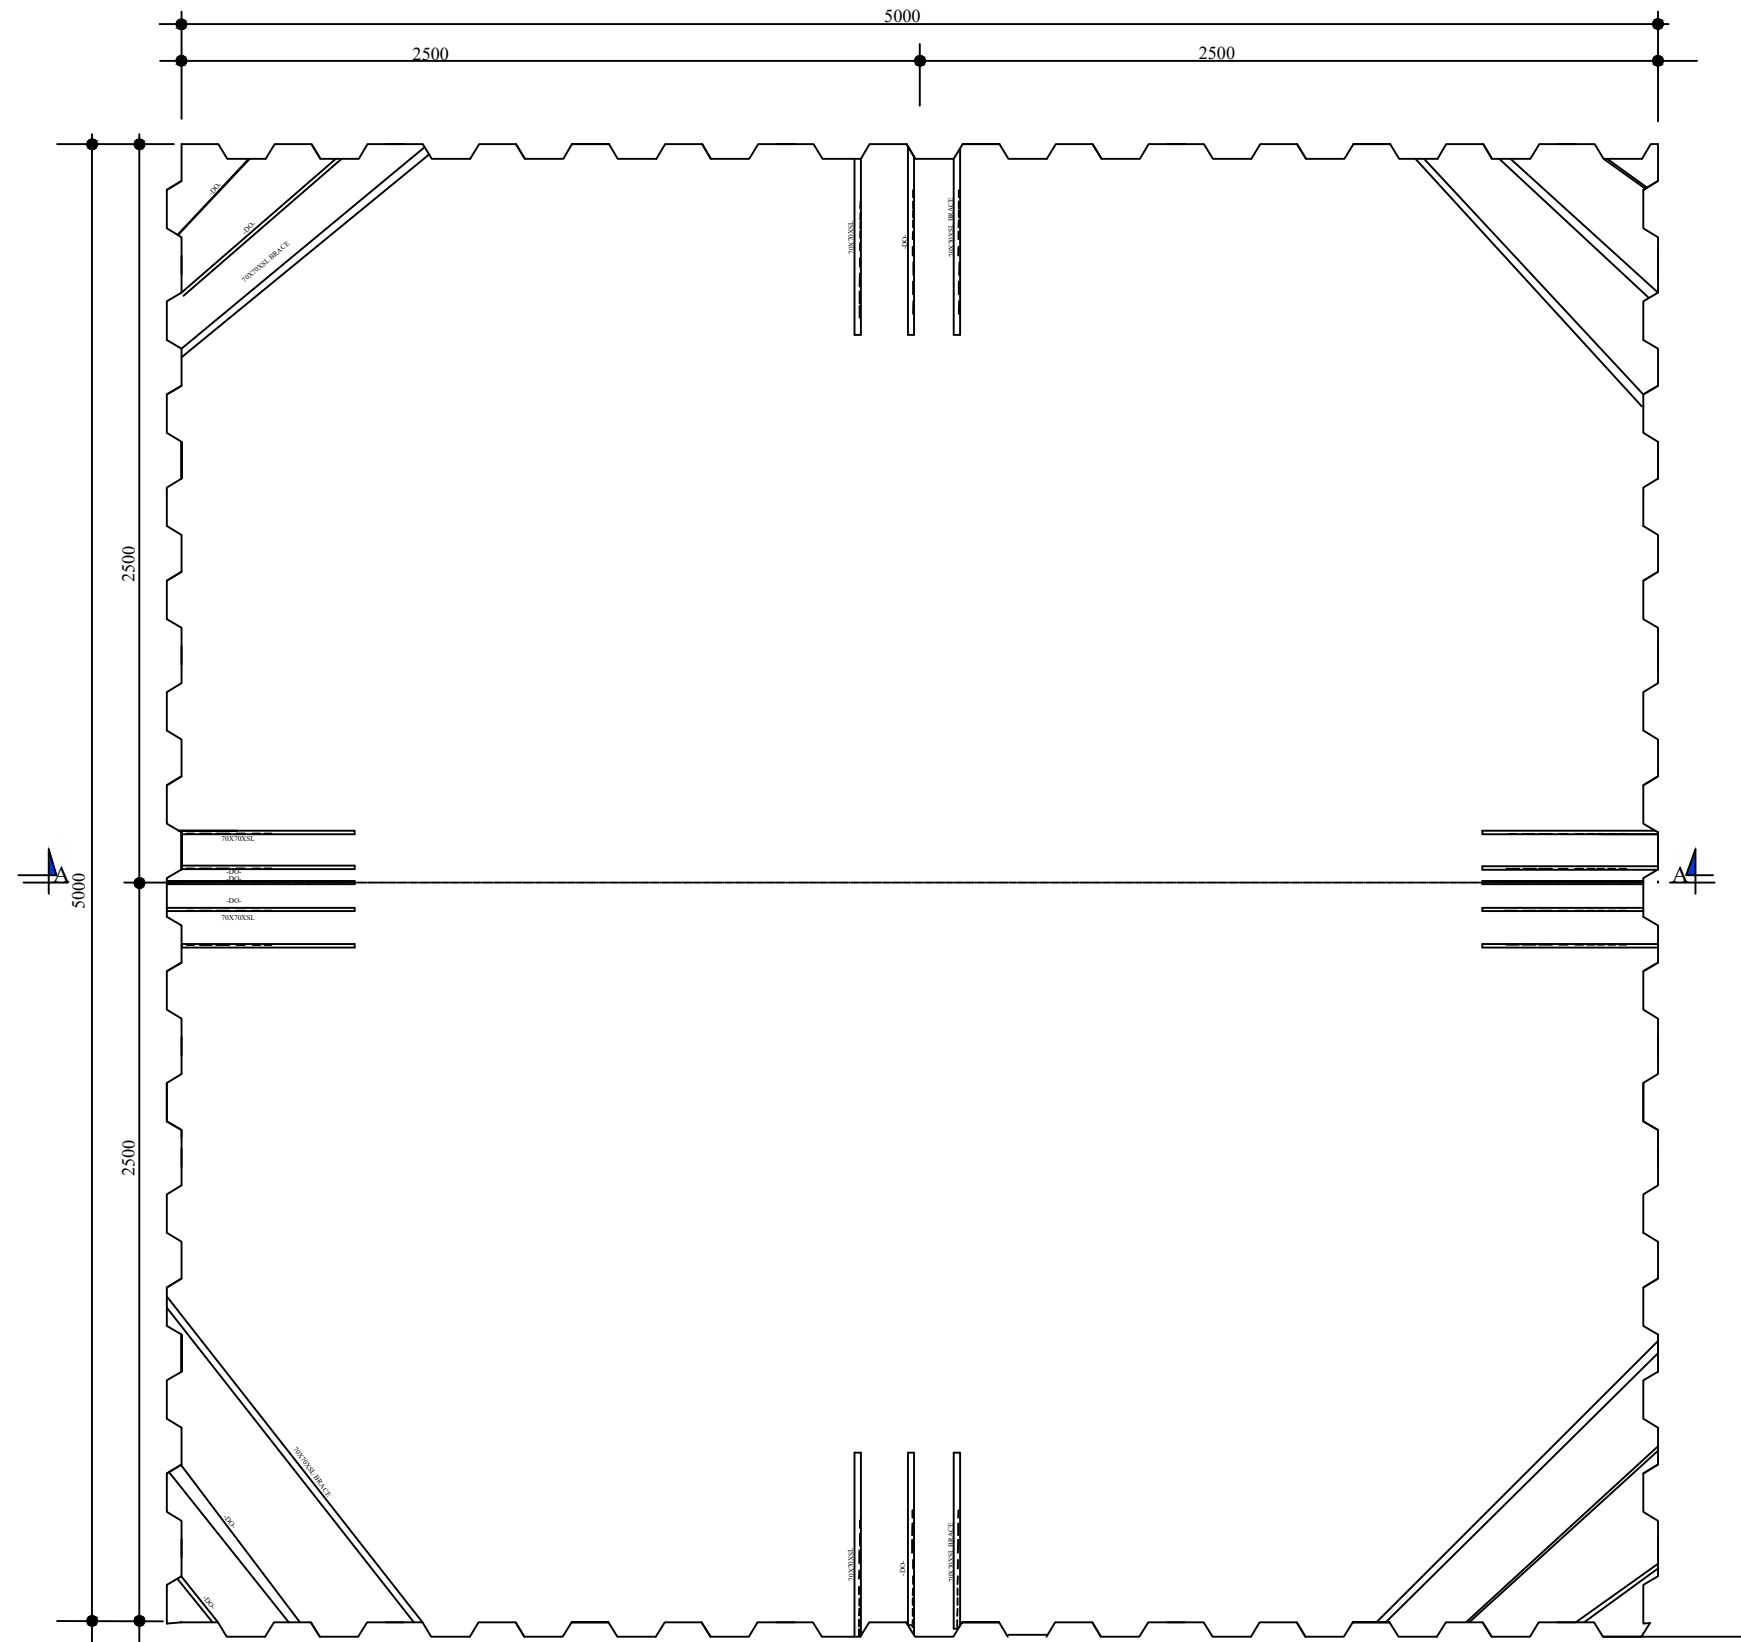

PLAN SHOWING INTERNAL BRACES (5m X 5m X 2.4m)

				CLIENT: USAID/MERCY CORPS CONSULTANT  KONSADEM ASSOCIATES LTD Engineers & Consultants 30, Onireke Layout, P.M. B. 5478, Ibadan, NIGERIA. E-mail:konsadem@gmail.com 2ML CONSULTING NIGERIA LTD Office 8, B1-Close Off 69(A) Road Gwarinpa Abuja, 	PROJECT ENGINEERING DESIGN OF WASH FACILITIES ACROSS BORNO, ADAMAWA AND YOBE (BAY) STATES Service Contract No: YOL SC 14 STATE ADAMAWA	SMALL TOWN DUMNE	DRAWING TITLE DUMNE MAIN WATER SCHEME SUCTION TANK 50 Cu.m) INTERNAL BRACES DETAILS DRAWING NO. BB/BD/05 SCALE	Designed: Engr Soji Drawn : Damola Traced : Checked : Engr Soji Date : MAY 2021 Ref. No: USAID/BAY/BU-00	STAMP	
Mark : Date : Made by : Revision										

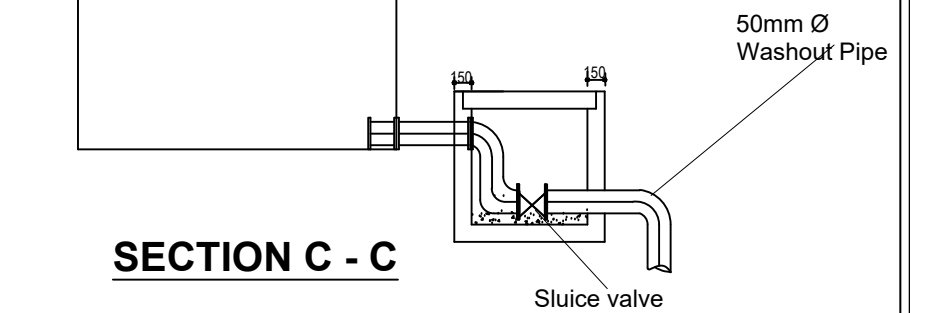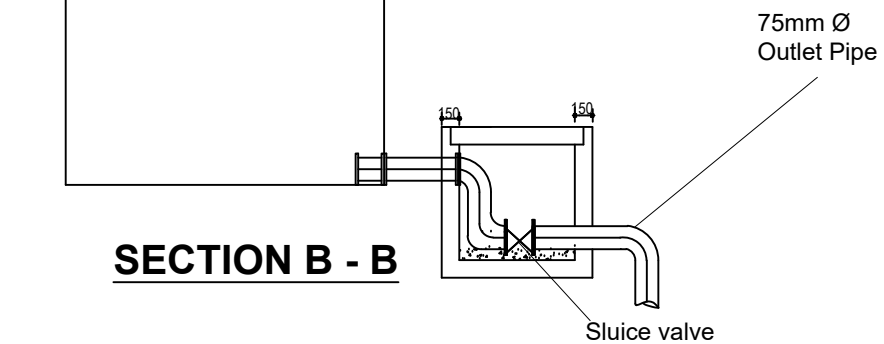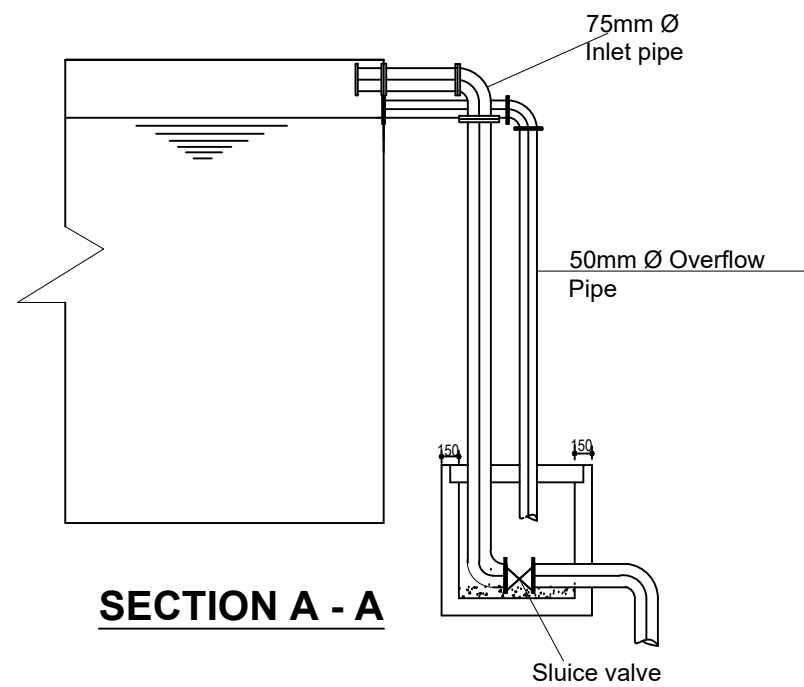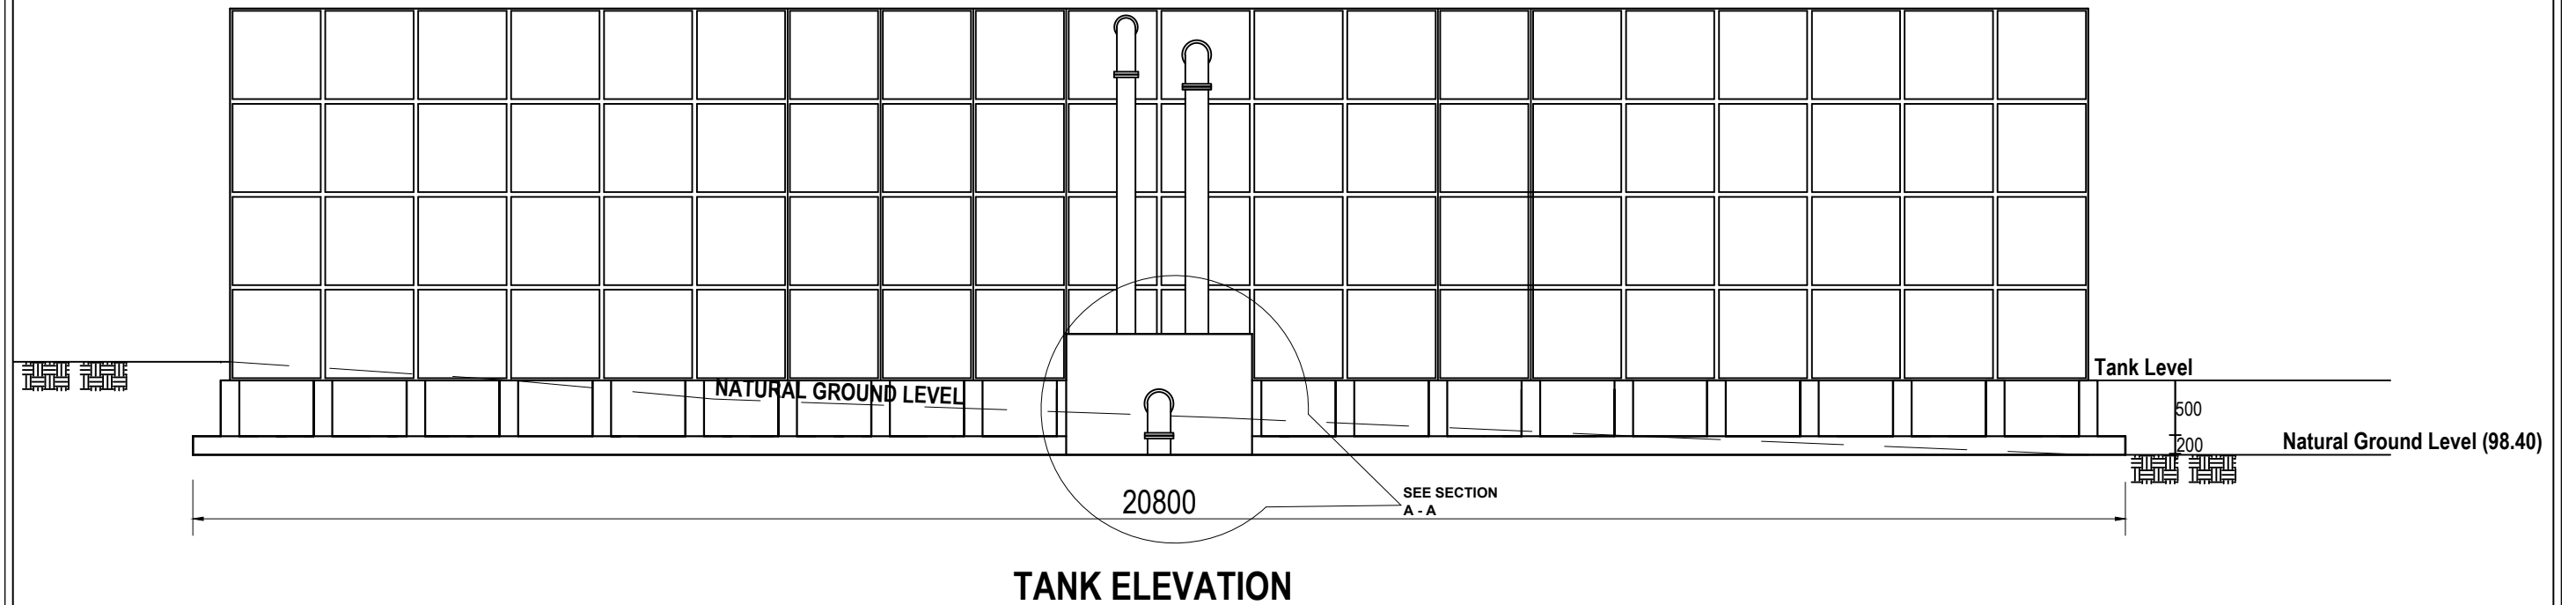

				CLIENT:	USAID/MERCY CORPS		PROJECT	SMALL TOWN		DRAWING TITLE		Designed: Engr Soji	STAMP
				CONSULTANT		KONSADEM ASSOCIATES LTD Engineers & Consultants 30, Onireke Layout, P.M. B. 5478, Ibadan, NIGERIA. E-mail: konsadem@gmail.com	2ML CONSULTING NIGERIA LTD Office 8, B1-Close Off 69(A) Road Gwarinpa Abuja,	ADAMAWA	DUMNE	DUMNE MAIN WATER SCHEME		Drawn : Damola	
										SUCTION TANK 50 Cu.m)		Traced : Engr Soji	
										ELEVATION AND DETAILS		Checked : Engr Soji	
												Date : MAY 2021	
Mark : Date : Made by : Revision							STATE		DRAWING NO.	SCALE	Ref. No:		
									AD/BD/OG		USAID/BAY/AD-OO		