

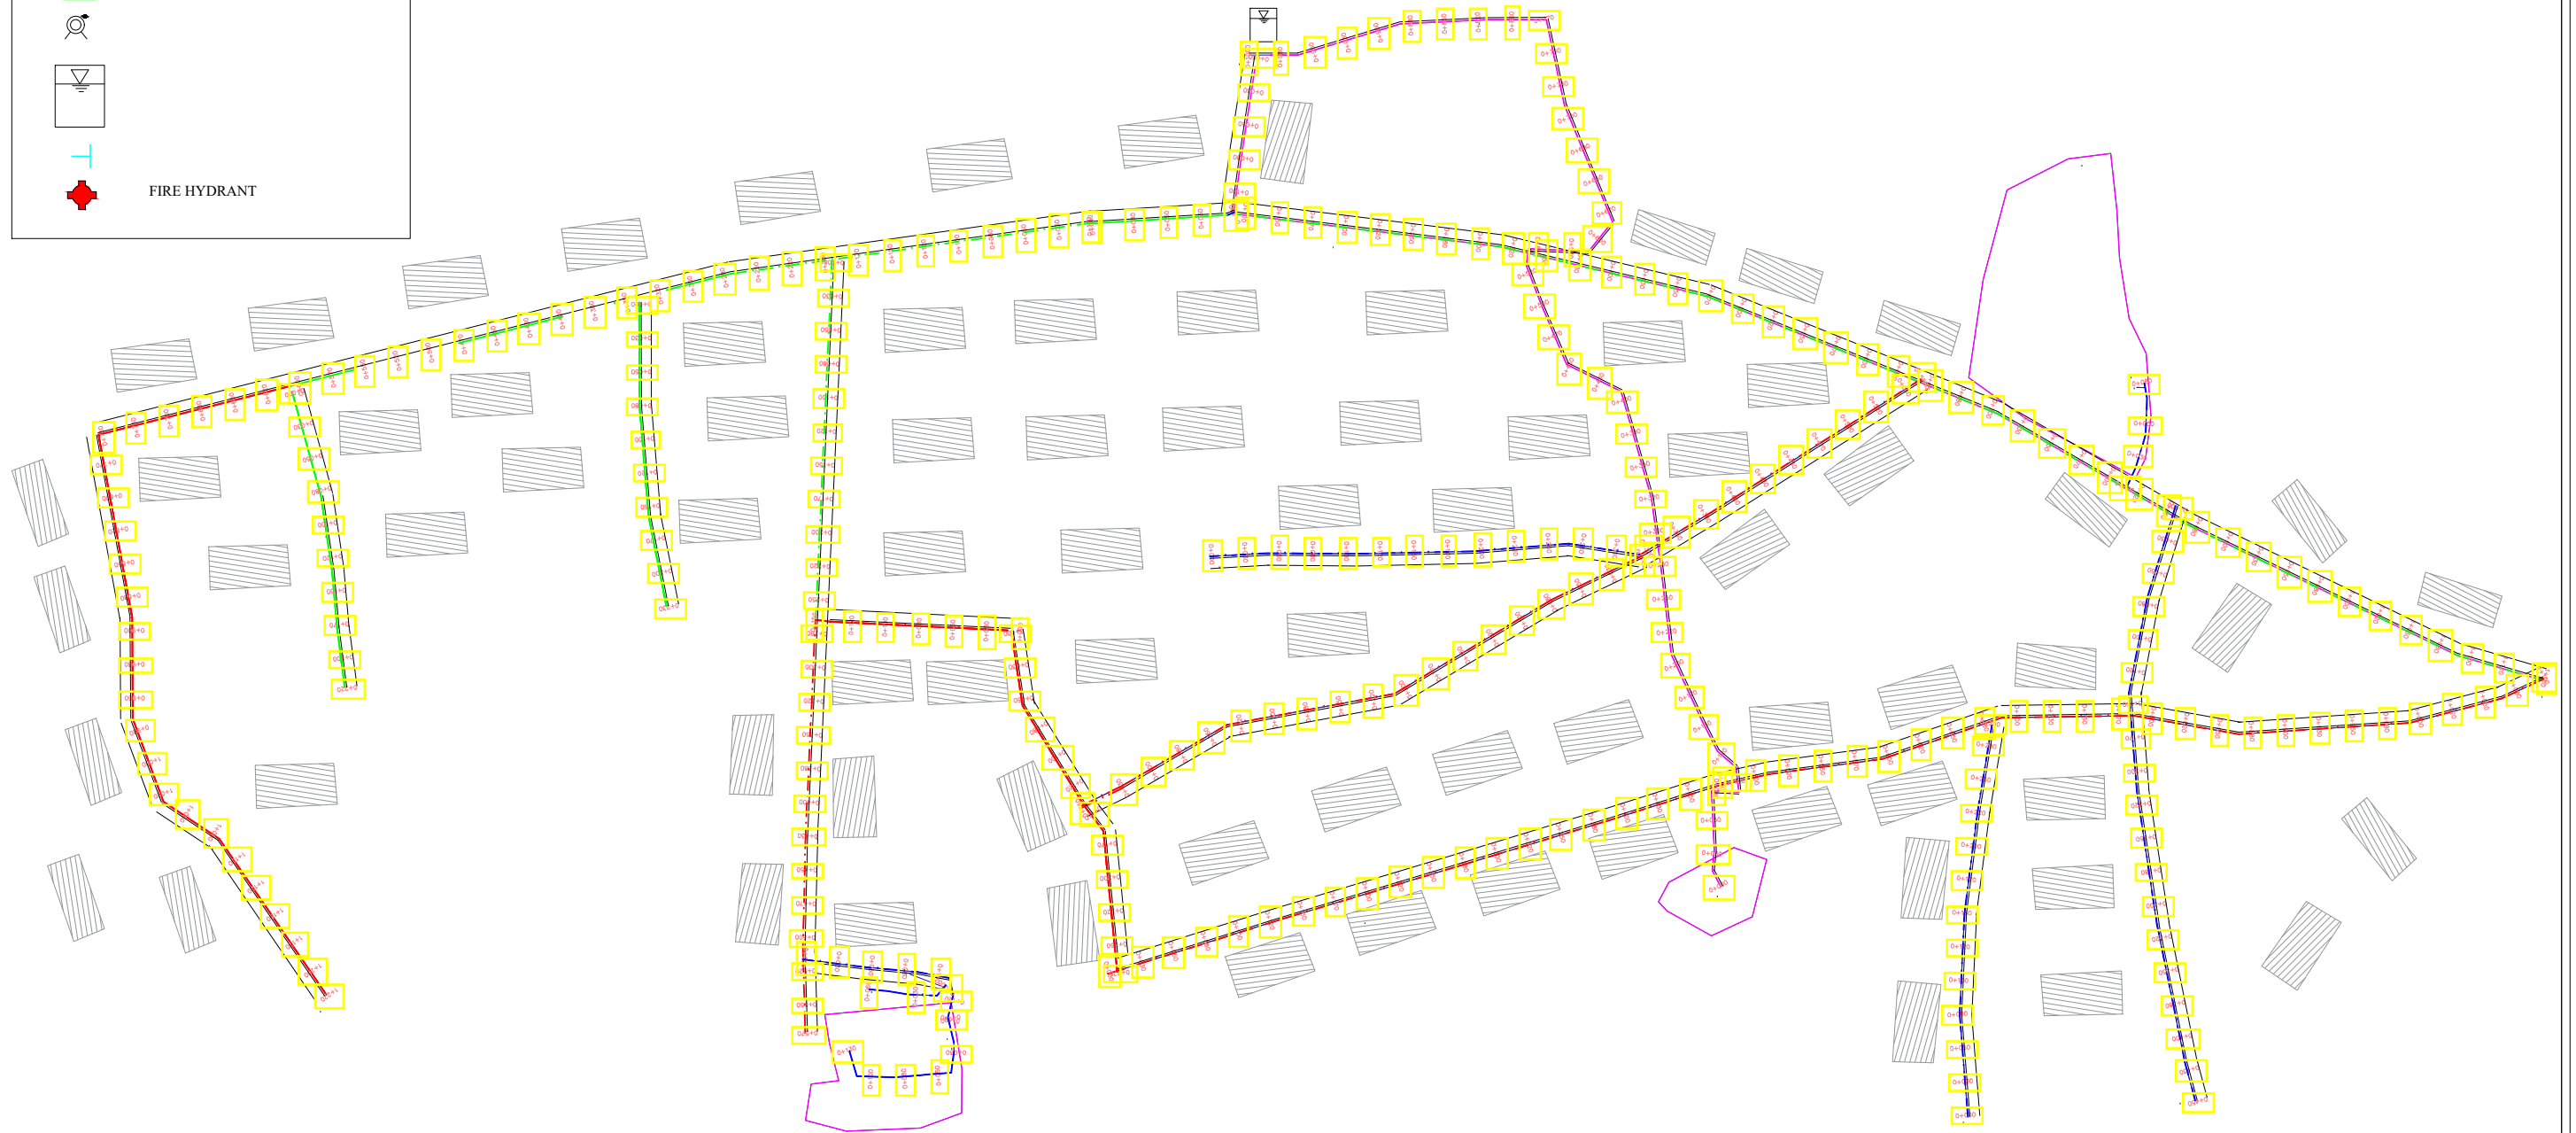



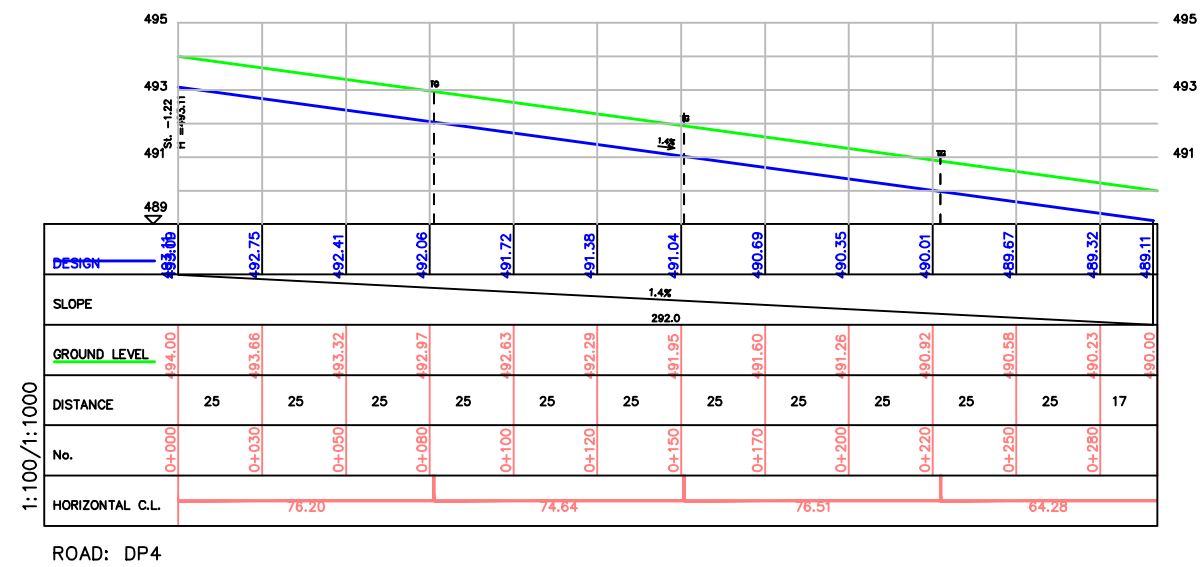


				CLIENT: USAID/MERCY CORPS CONSULTANT  KONSADEM ASSOCIATES LTD Engineers & Consultants 30, Onireke Layout, P.M. B. 5478, Ibadan, NIGERIA. E-mail:konsadem@gmail.com 2ML CONSULTING NIGERIA LTD Office 8, B1-Close Off 69(A) Road Gwarinpa Abuja,  PROJECT ENGINEERING DESIGN OF WASH FACILITIES ACROSS BORNO, ADAMAWA AND YOBE (BAY) STATES Service Contract No:YOL SC 14 STATE ADAMAWA SMALL TOWN GANYE DRAWING TITLE GENERAL LAYOUT DRAWING NO. AG/GL/O I SCALE Designed: Engr Soji Drawn : Damola Traced : Checked : Engr Soji Date : MAY 2021 Ref. No: USAID/BAY/AD-00 STAMP
Mark : Date : Made by : Revision				


[illegible]

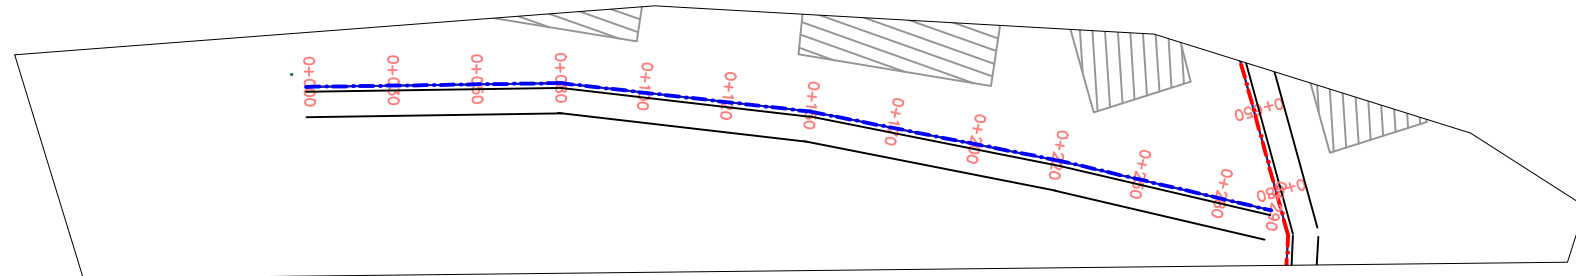

				CLIENT:	USAID/MERCY CORPS					PROJECT	SMALL TOWN		DRAWING TITLE		Designed: Engr Soji		STAMP
				CONSULTANT	KONSADEM ASSOCIATES LTD Engineers & Consultants 30, Gwinda Layout, P.M. B. 6478, Ibadan, NIGERIA. E-mail:konsadem@gmail.com ZML CONSULTING NIGERIA LTD Office 8, S1-Clase Off 66(A) Road Gwerinpa Abaka, ADAMAWA					GANYE		DISTRIBUTION NETWORK PLAN AND PROFILE: DP ROAD 5 CH. 0+00 - 0+650.00		Drawn : Damola			
Traced :																	
Checked : Engr Soji																	
Date : MAY 2021																	
Mark : Date : Made by : Revision									STATE	ADAMAWA		DRAWING NO.	SCALE	Ref. No: USAI/BAY/BU-00			
												BB/BD/O I					

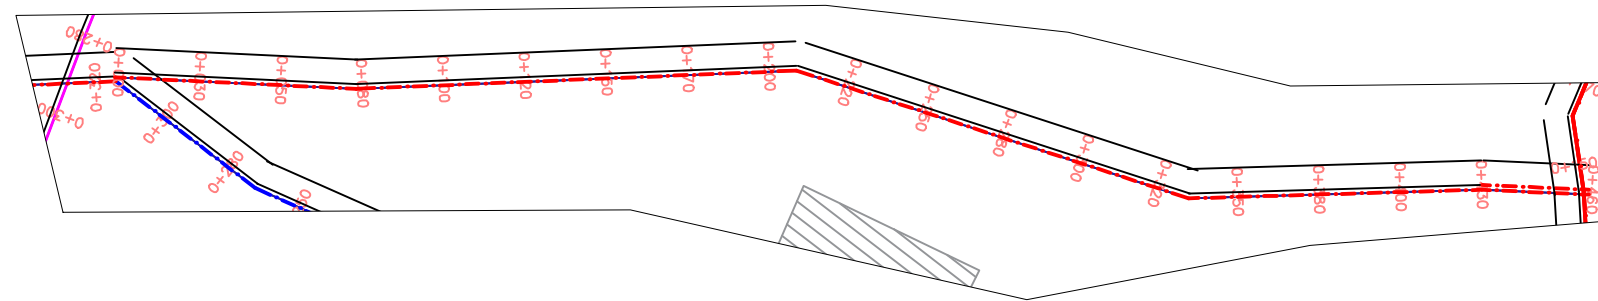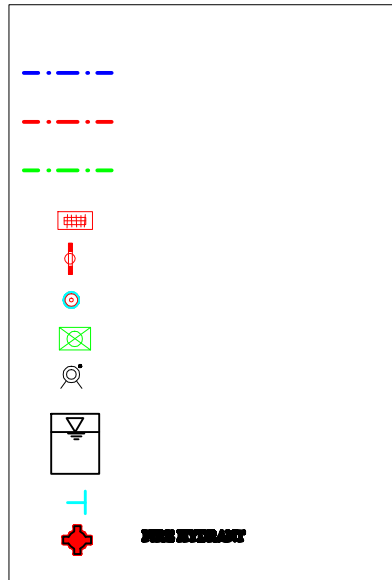


PLAN

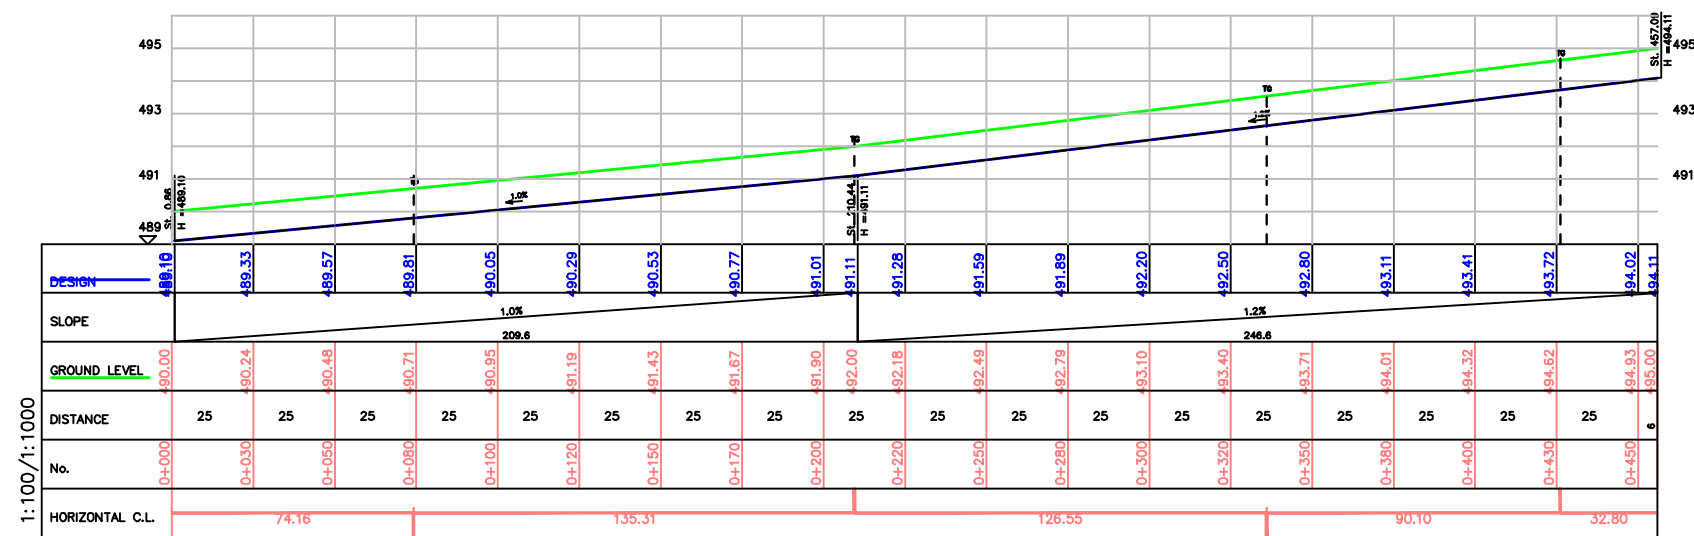


ROAD: DP6

PROFILE

				CLIENT:	USAID/MERCY CORPS			PROJECT	SMALL TOWN		DRAWING TITLE		Designed: Engr Soji	STAMP
				CONSULTANT	KONSADEM ASSOCIATES LTD Engineers & Consultants 36, Oluwalope Layout, P.M. B. 6478, Ikotaku, NIGERIA. E-mail: konsadem@gmail.com		2ML CONSULTING NIGERIA LTD Office 3, 81-Class Off (a/a) Road Gweriye Abba,	ENGINEERING DESIGN OF WASH FACILITIES ACROSS BORNO, ADAMAWA AND YOBE (BAY) STATES Service Contract No: YOL SC 14	GANYE	DISTRIBUTION NETWORK PLAN AND PROFILE: DP ROAD 6 CH. 0+000 - 0+450.00	DRAWING NO. SCALE		Drawn : Damola	
Mark: Date: Made by: Revision								STATE	ADAMAWA	BB/BD/OI		Traced : Engr Soji		
												Checked : Engr Soji		
												Date : MAY 2021		
												Ref. No:		
												USAID/BAYBU-00		

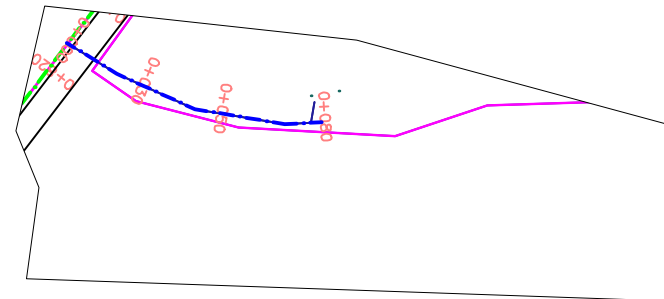



PLAN

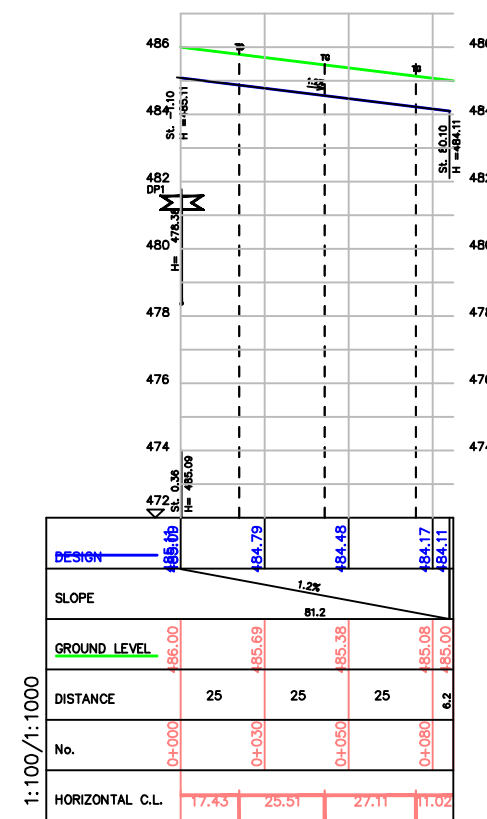


ROAD: DP7

PROFILE

				CLIENT:	USAID/MERCY CORPS	PROJECT	ENGINEERING DESIGN OF WASH FACILITIES ACROSS BORNO, ADAMAWA AND YOBE (BAY) STATES	SMALL TOWN	GANYE	DRAWING TITLE	DISTRIBUTION NETWORK	Designed:	Engr Soji	STAMP
				CONSULTANT	KONSADEM ASSOCIATES LTD	2ML CONSULTING NIGERIA LTD	Office 2, 51-Close Off 60(A) Road			PLAN AND PROFILE: DP ROAD 7	Traced:	Damola		
					Engineers & Consultants		Overlaping Abuja.			CH. 0+000 - 0+080.00	Checked:	Engr Soji		
					30, Onitsha Layout,						Date:	MAY 2021		
					P.M. B. 5478, Ibadan, NIGERIA.									
					E-mail: konsadem@gmail.com									
Mark:	Date:	Made by:	Revision					STATE	ADAMAWA	DRAWING NO.	BB/BD/O I	Ref. No:	USAID/BAY/BU-00	

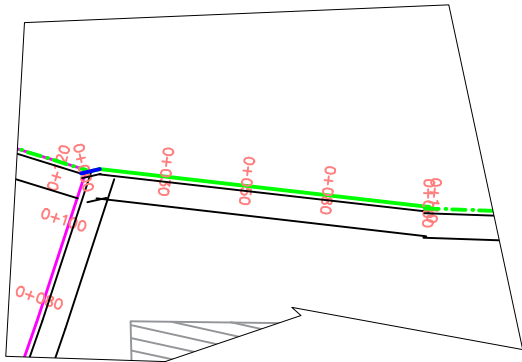 



PLAN

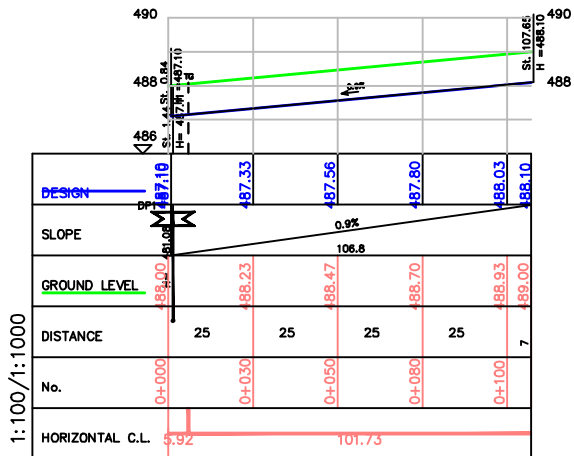


ROAD: DP8

PROFILE

				CLIENT:	USAID/MERCY CORPS	PROJECT	SMALL TOWN	DRAWING TITLE	Designed: Engr Soji	STAMP
				CONSULTANT	KONSADEM ASSOCIATES LTD Engineers & Consultants 28, Oritso Layout, P.M. S. 6478, Ibadan, NIGERIA. E-mail: konsadem@gmail.com 2ML CONSULTING NIGERIA LTD Office 2, 81-Globe Off 60(A) Road Gwarinpa Abuja,	ENGINEERING DESIGN OF WASH FACILITIES ACROSS BORNO, ADAMAWA AND YOBE (BAY) STATES Service Contract No: YOL SC 14	GANYE	DISTRIBUTION NETWORK PLAN AND PROFILE: DP ROAD 8 CH. 0+000 - 0+100.00	Drawn : Damola	
						STATE		DRAWING NO. SCALE	Checked : Engr Soji	
Mark :	Date :	Made by :	Revision			ADAMAWA		BB/BD/O I	Date : MAY 2021	Ref. No: USAID/BAY/BU-00

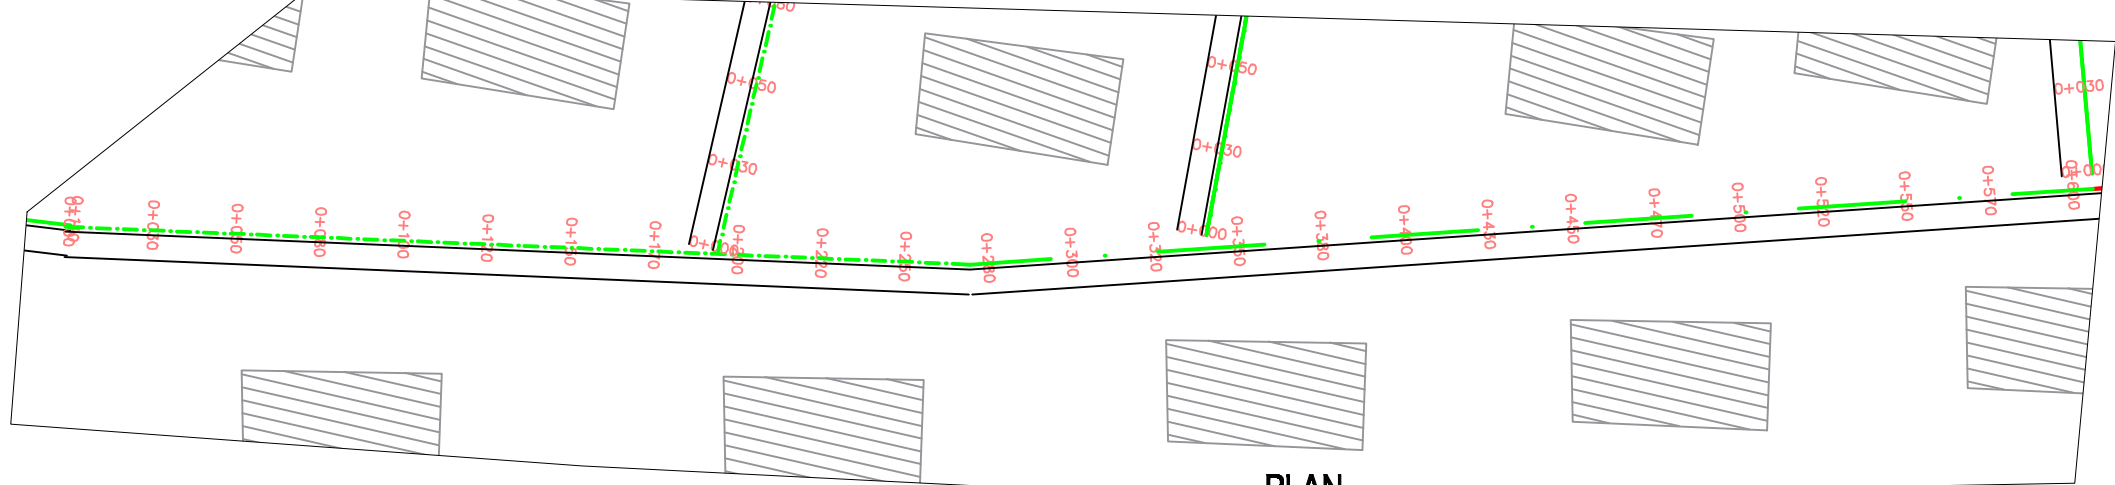 



PLAN

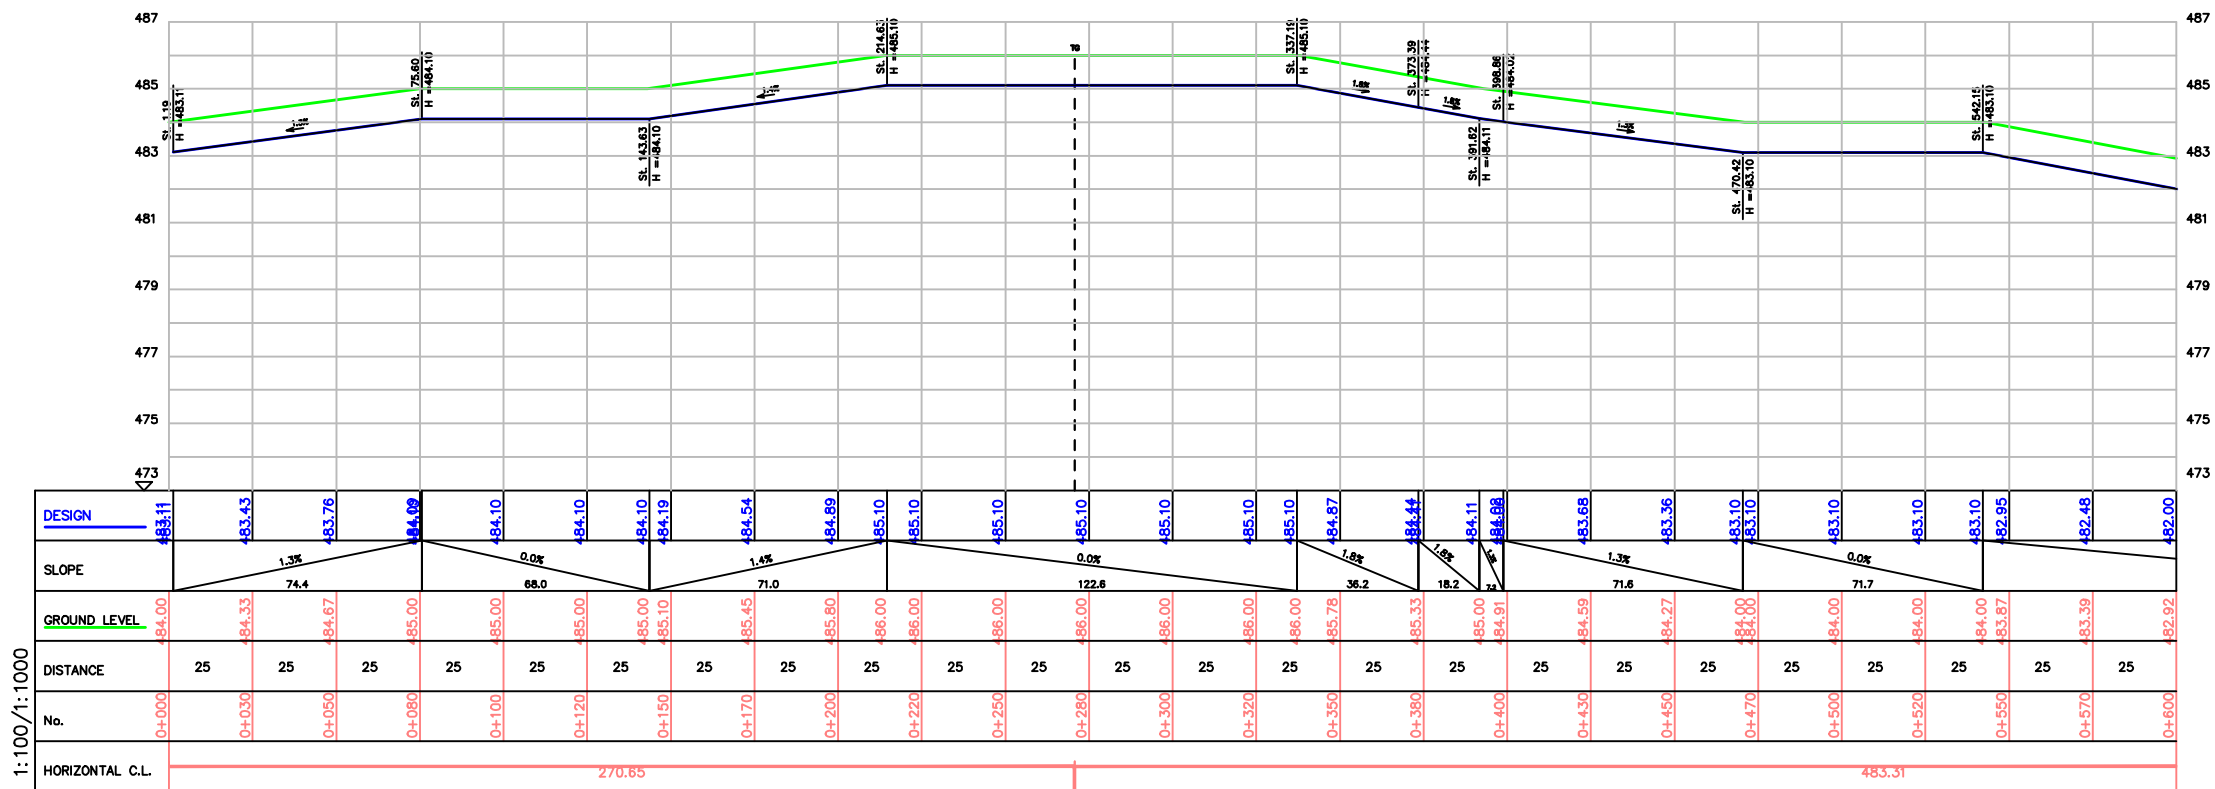

ROAD: DP9




PROFILE

				CLIENT:				USAID/MERCY CORPS				PROJECT				SMALL TOWN				DRAWING TITLE				Designed: Engr Soji				STAMP			
				CONSULTANT				KONSADM ASSOCIATES LTD				ENGINEERING DESIGN OF WASH FACILITIES ACROSS BORNO, ADAMAWA AND YOBE (BAY) STATES				GANYE				DISTRIBUTION NETWORK				Drawn : Damola							
								2ML CONSULTING NIGERIA LTD				Service Contract No: YOL SC 14								CH. 0+000 - 0+600.00				Traced : Engr Soji							
												STATE								DRAWING NO.				Checked : Engr Soji							
Mark : Date : Made by : Revision												ADAMAWA								BB/BD/OI				Date : MAY 2021							
																				SCALE				Ref. No:							
																								USAID/BAY/BU-00							

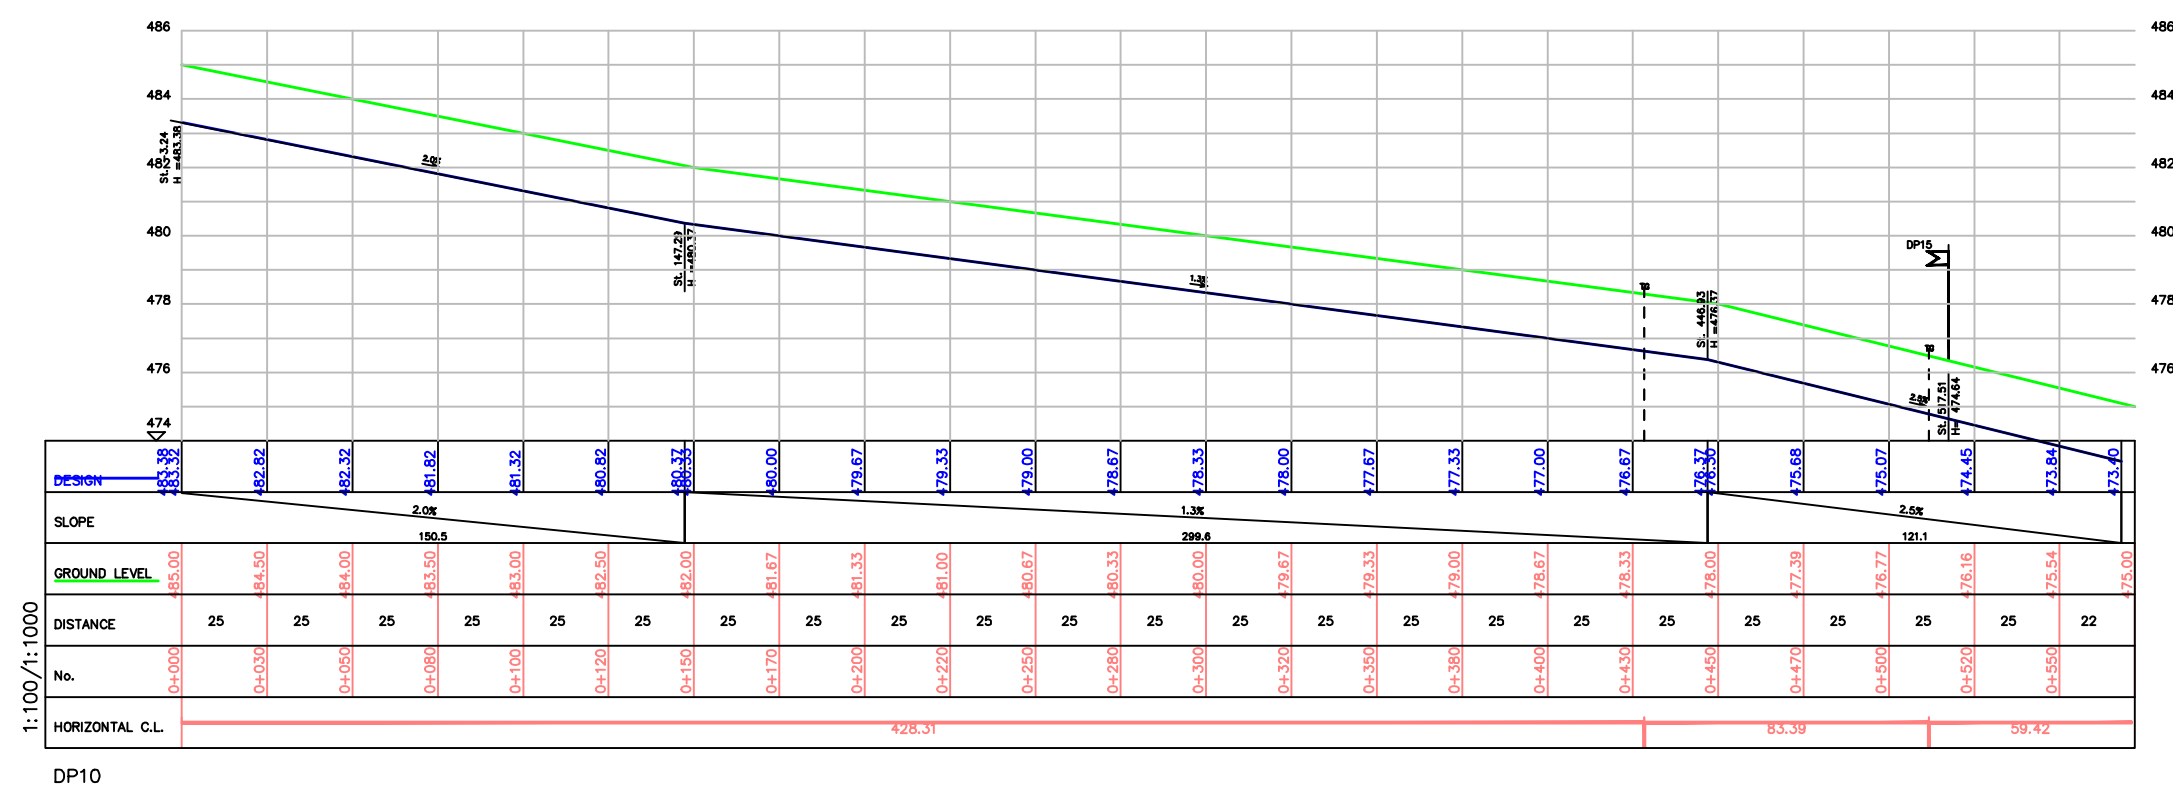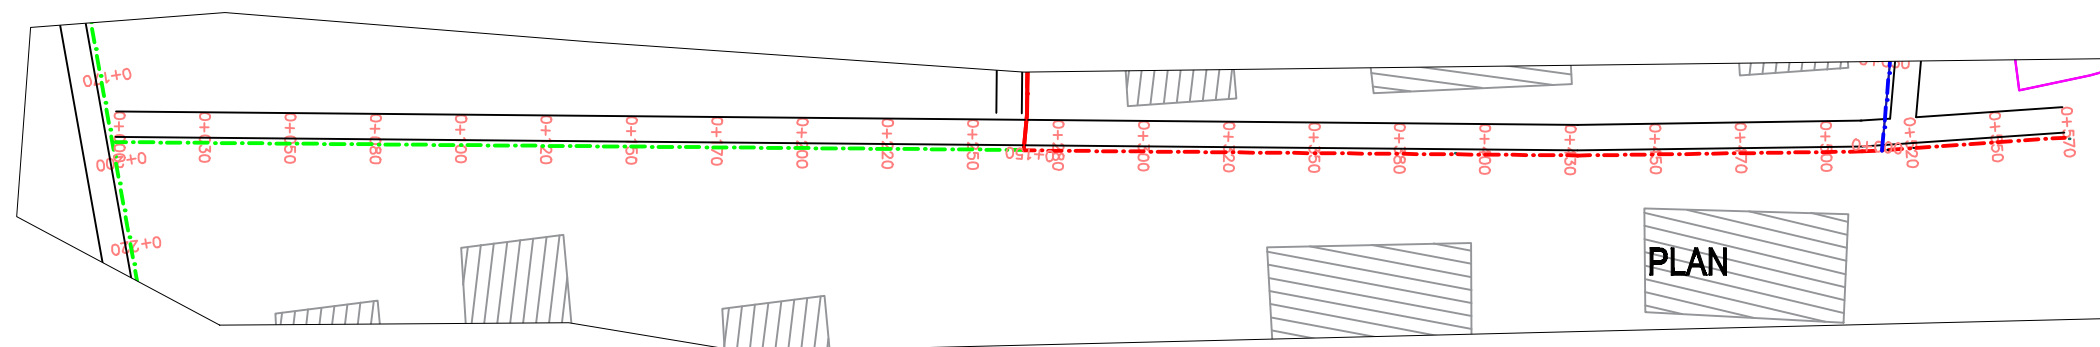

PROFILE

 [illegible]

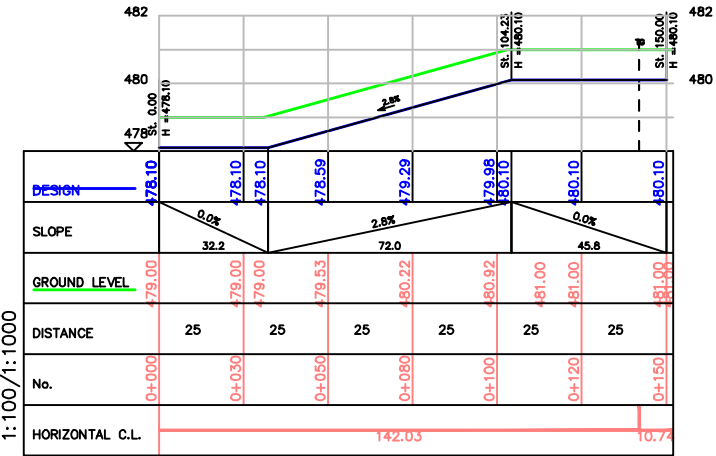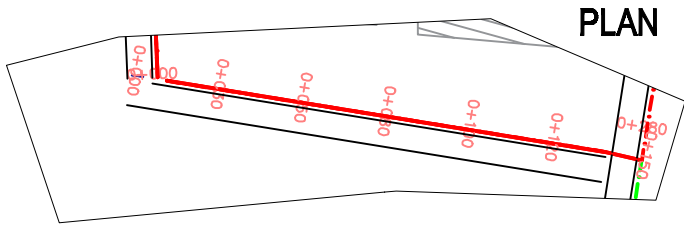

DP11

PROFILE

Mark :	Date :	Made by :	Revision



CLIENT: USAID/MERCY CORPS

CONSULTANT: **KONSADAM ASSOCIATES LTD**
Engineers & Consultants
30, Onirake Layout,
P.M. B. 8478, Ibadan, NIGERIA.
E-mail: konsadam@gmail.com

2ML CONSULTING NIGERIA LTD
Office 8, 51-Close Off 68(A) Road
Gwarinpa Abuja,



PROJECT: **ENGINEERING DESIGN OF WASH FACILITIES ACROSS BORNO, ADAMAWA AND YOBE (BAY) STATES**
Service Contract No: YOL SC 14

STATE: ADAMAWA

SMALL TOWN: GANYE



DRAWING TITLE: **DISTRIBUTION NETWORK**
PLAN AND PROFILE: DP ROAD 11
CH. 0+000 - 0+150.00

DRAWING NO.	SCALE
BB/BD/01	

Designed: Engr. Soy
Drawn: Damola
Traced:
Checked: Engr. Soy
Date: MAY 2021


Ref. No: USAID/BAY/BU-00

STAMP

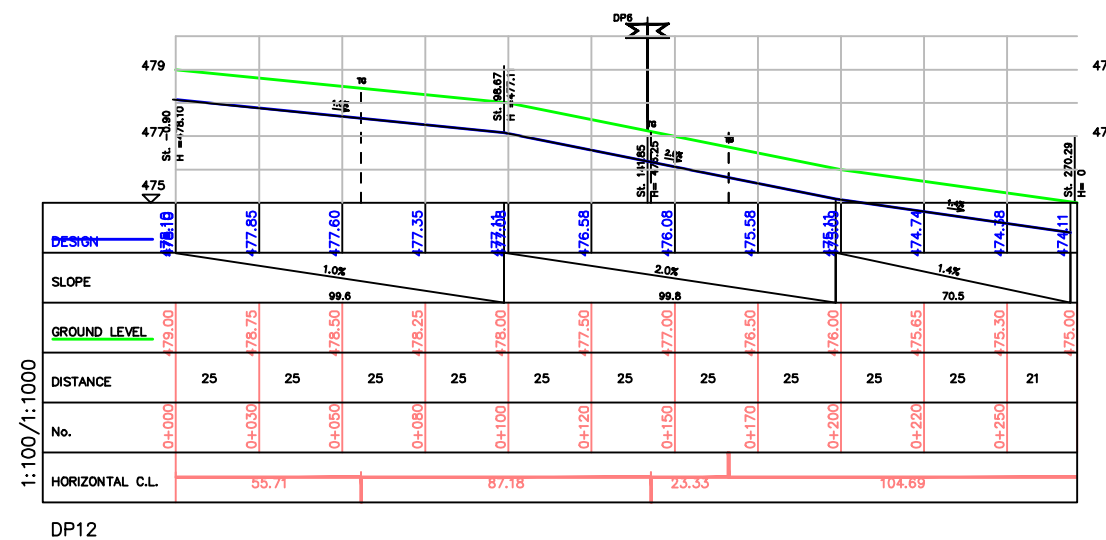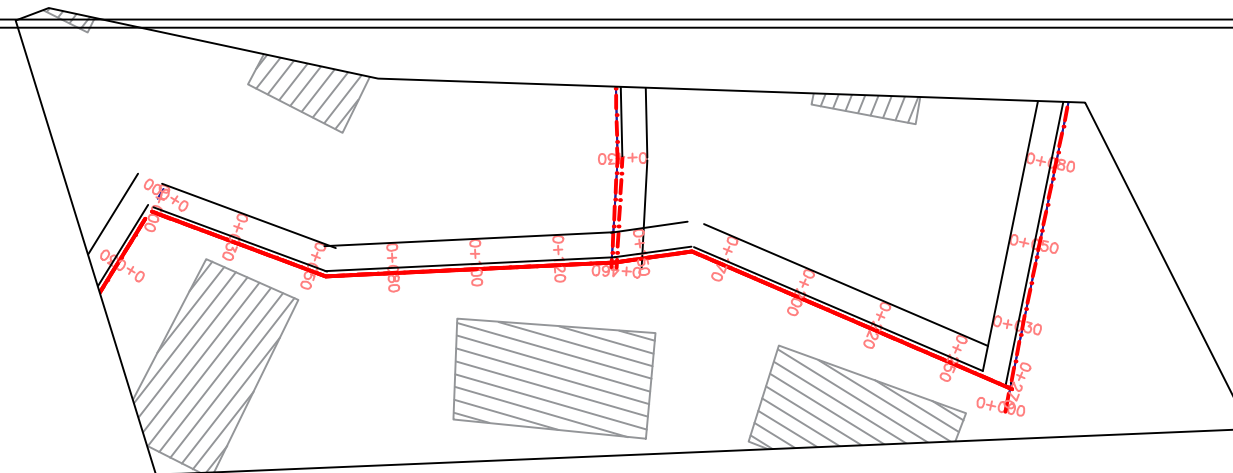


				CLIENT:	USAID/MERCY CORPS	PROJECT	ENGINEERING DESIGN OF WASH FACILITIES ACROSS BORNO, ADAMAWA AND YOBE (BAY) STATES Service Contract No: YOL SC 14	SMALL TOWN	GANYE	DRAWING TITLE	DISTRIBUTION NETWORK PLAN AND PROFILE: DP ROAD 12 CHL 0+000 - 0+250.00	Designed: Engr Soy Drawn : Damola Traced : Checked : Engr Soy Date : MAY 2021	STAMP
				CONSULTANT	KONSADEM ASSOCIATES LTD Engineers & Consultants 90, Oshole Layout, P.M.B. 5478, Ibadan, NIGERIA. E-mail: konsadem@gmail.com	2ML CONSULTING NIGERIA LTD Office & B1-Clone Off 66(A) Road Overlapse Abuja,	STATE	ADAMAWA		DRAWING NO.	BB/BD/O I	SCALE	Ref. No: USAID/BAY/BU-OO
Mark : Date : Made by : Revision													

PLAN

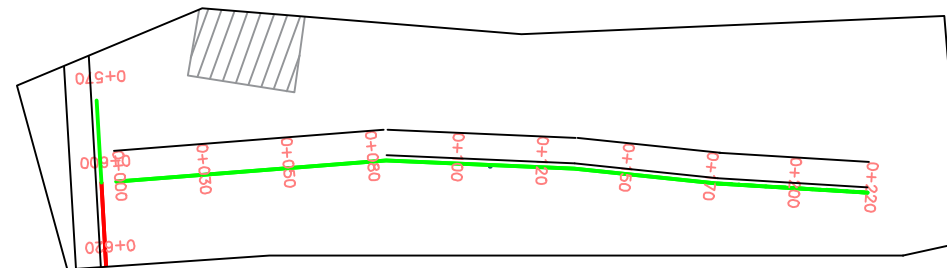


PROFILE

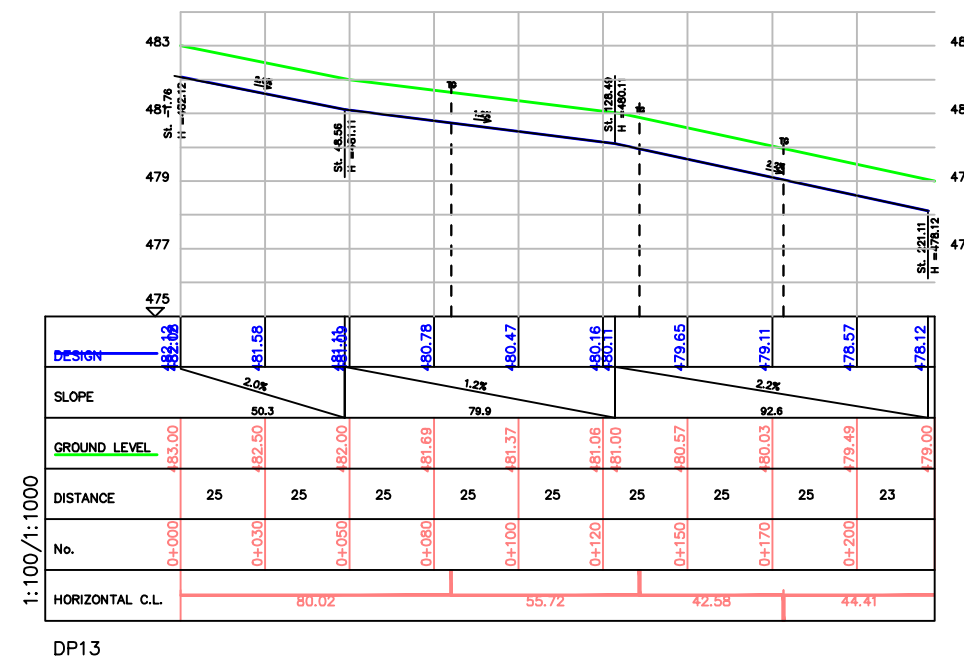


				CLIENT:	USAID/MERCY CORPS	PROJECT	ENGINEERING DESIGN OF WASH FACILITIES ACROSS BORNO, ADAMAWA AND YOBE (BAY) STATES	SMALL TOWN	GANYE	DRAWING TITLE	DISTRIBUTION NETWORK PLAN AND PROFILE: DP ROAD 13 CH. 0+000 - 0+200.00	Designed: Engr Soji	STAMP
				CONSULTANT	KONSADEM ASSOCIATES LTD Engineers & Consultants 20, Onirika Layout, P.M. B. 8478, Ibadan, NIGERIA. E-mail: konsadem@gmail.com	STATE	ADAMAWA					Drawn : Damola	
					2ML CONSULTING NIGERIA LTD Office 8, 81-Close Off 80(A) Road Gwarimpa Abuja,							Traced : Engr Soji	
												Checked : Engr Soji	
												Date : MAY 2021	
Mark :	Date :	Made by :	Revision							DRAWING NO.	BB/BD/01	Ref. No:	USAID/BAY/BU-00

PLAN

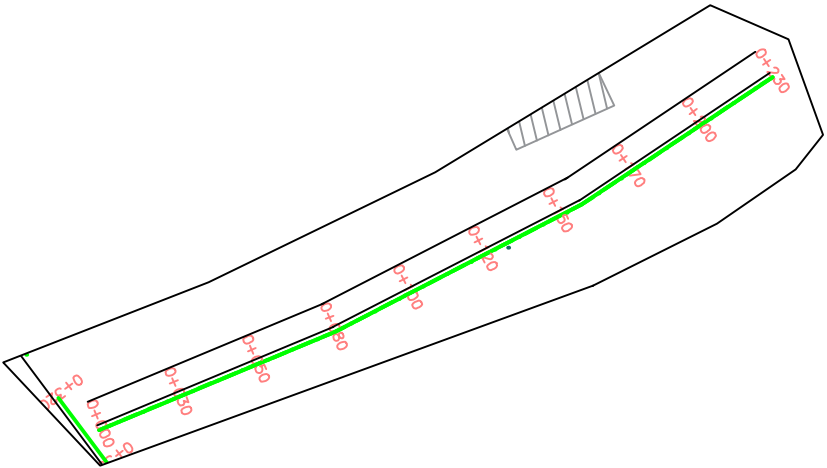


PROFILE

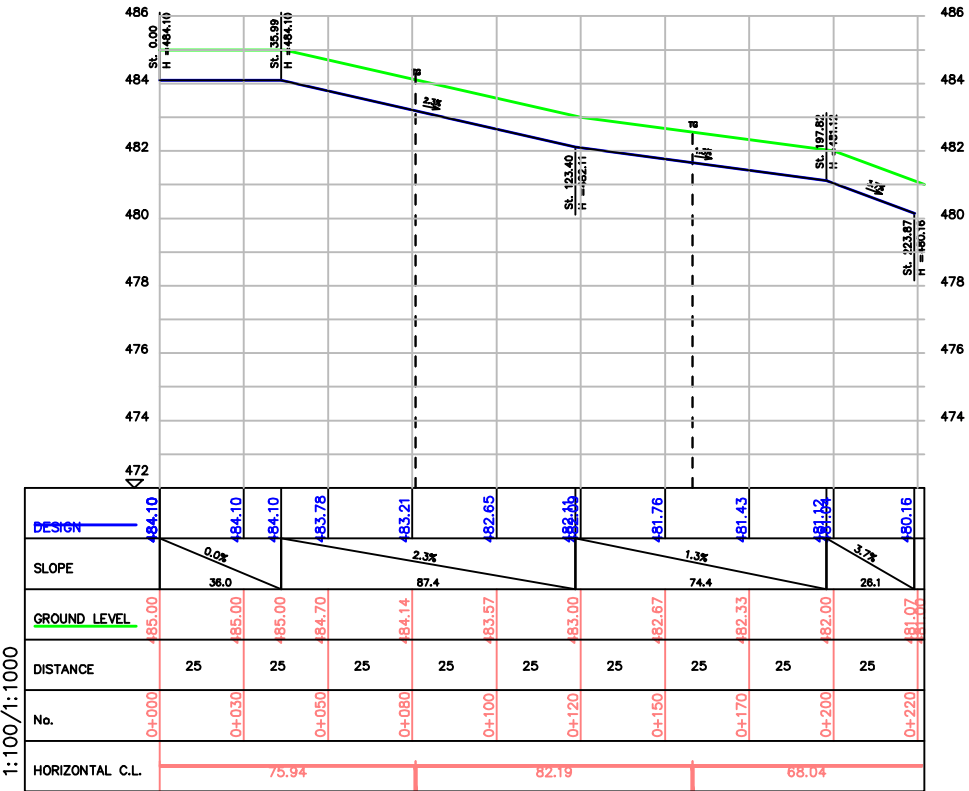


DP14

				CLIENT:	USAID/MERCY CORPS			PROJECT	SMALL TOWN		DRAWING TITLE		Designed:	Engr Soji	STAMP
				CONSULTANT	KONSADEM ASSOCIATES LTD Engineers & Consultants 50, Onitoke Layout, P.M. B. 6478, Ibadan, NIGERIA. E-mail:konsadem@gmail.com			ENGINEERING DESIGN OF WASH FACILITIES ACROSS BORNO, ADAMAWA AND YOBE (BAY) STATES Service Contract No: YOL SC 14	GANYE	DISTRIBUTION NETWORK PLAN AND PROFILE: DP ROAD 14 CH. 0+000 - 0+220.00	DRAWING NO. BB/BD/O I	SCALE	Drawn :	Damola	
					ZML CONSULTING NIGERIA LTD Office 8, 81-Class Off 66(A) Road Gwarinpa Abuja ,								Traced :		
													Checked :	Engr Soji	
													Date :	MAY 2021	
													Ref. No:	USAID/BAY/BU-00	
Mark : Date : Made by : Revision								STATE	ADAMAWA						

PLAN

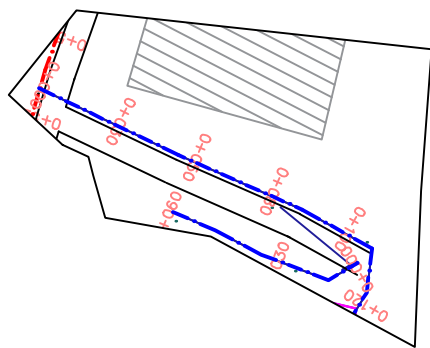

PROFILE

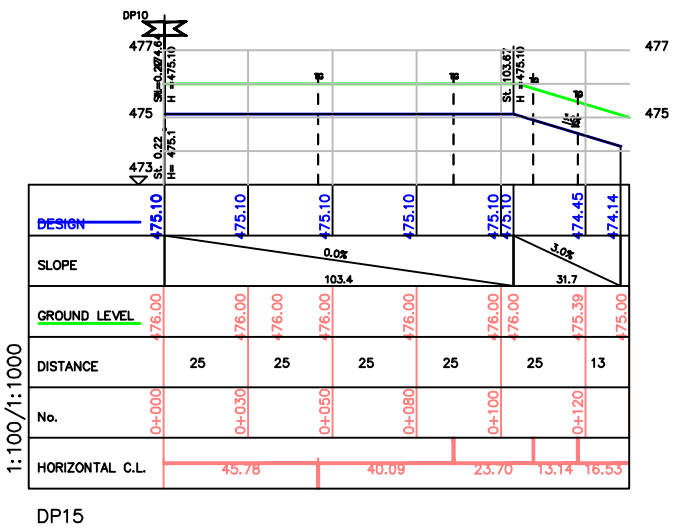

Mark :	Date :	Made by :	Revision

CLIENT:	USAID/MERCY CORPS
CONSULTANT	KONSADEM ASSOCIATES LTD Engineers & Consultants 20, Onitsha Layout, P.M. B. 6478, Ibadan, NIGERIA E-mail: konsadem@gmail.com
	ZML CONSULTING NIGERIA LTD Office 8, 83-Clase Off (8/4) Road Gwarinpa Abuja,




PROJECT	ENGINEERING DESIGN OF WASH FACILITIES ACROSS BORNO, ADAMAWA AND YOBE (BAY) STATES Service Contract No: YOL SC 14
STATE	ADAMAWA

SMALL TOWN	GANYE
------------	-------


DRAWING TITLE	DISTRIBUTION NETWORK PLAN AND PROFILE: DP ROAD 15 CH. 0+000 - 0+120.00
DRAWING NO.	BB/BD/O I
SCALE	

Designed:	Engr Soji	STAMP
Drawn :	Damola	
Traced :		
Checked :	Engr Soji	
Date :	MAY 2021	
Ref. No:	USAID/BAY/BU-00	

PLAN

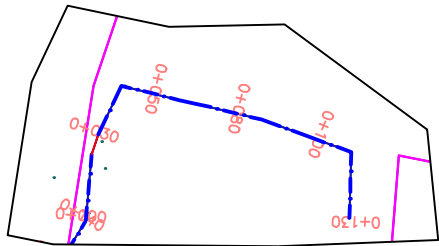

PROFILE

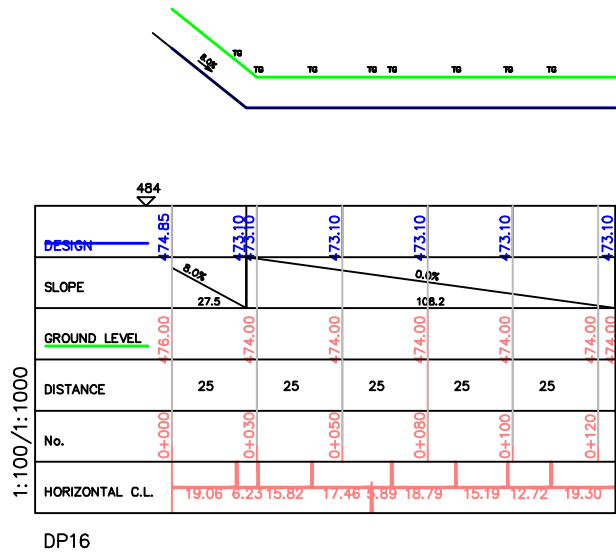

Mark :	Date :	Made by :	Revision

CLIENT: USAID/MERCY CORPS

CONSULTANT



KONSADM ASSOCIATES LTD
Engineers & Consultants
30, Onitsha Layout,
P.M. B. 5478, Ibadan, NIGERIA.

2ML CONSULTING NIGERIA LTD
Office 8, 51-Classe Off 69(A) Road
Gwarinpa Abuja.

E-mail: konsadem@gmail.com



PROJECT
**ENGINEERING DESIGN OF WASH
FACILITIES ACROSS BORNO, ADAMAWA
AND YOBE (BAY) STATES**
Service Contract No: YOL SC 14
STATE
ADAMAWA

SMALL TOWN
GANYE

DRAWING TITLE
DISTRIBUTION NETWORK
PLAN AND PROFILE: DP ROAD 16
CH. 0+000 - 0+120.00



DRAWING NO.
BB/BD/O 1

SCALE

Designed: Engr Soy
Drawn : Damola
Traced :
Checked : Engr Soy
Date : MAY 2021


Ref. No:
USAID/BAY/BU-00

STAMP

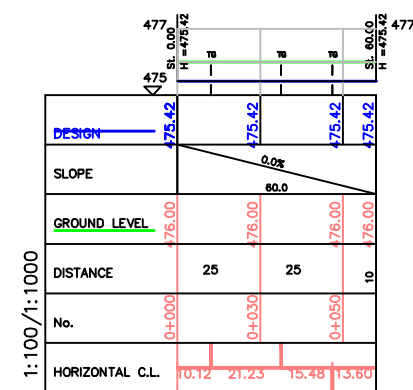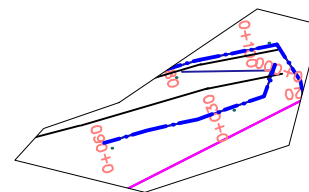


PROFILE

[illegible]

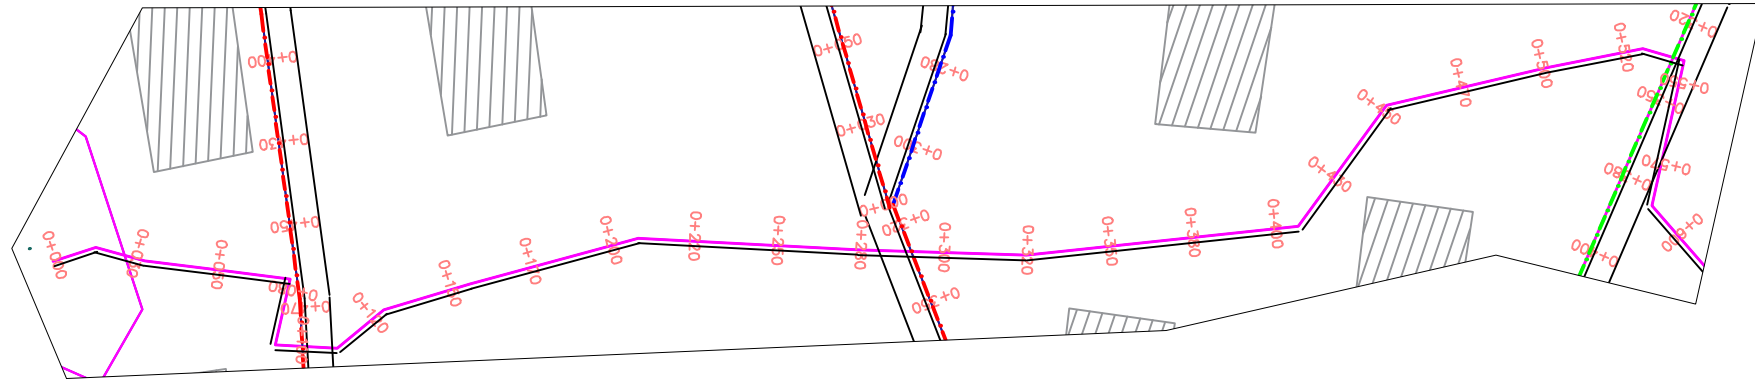


PLAN

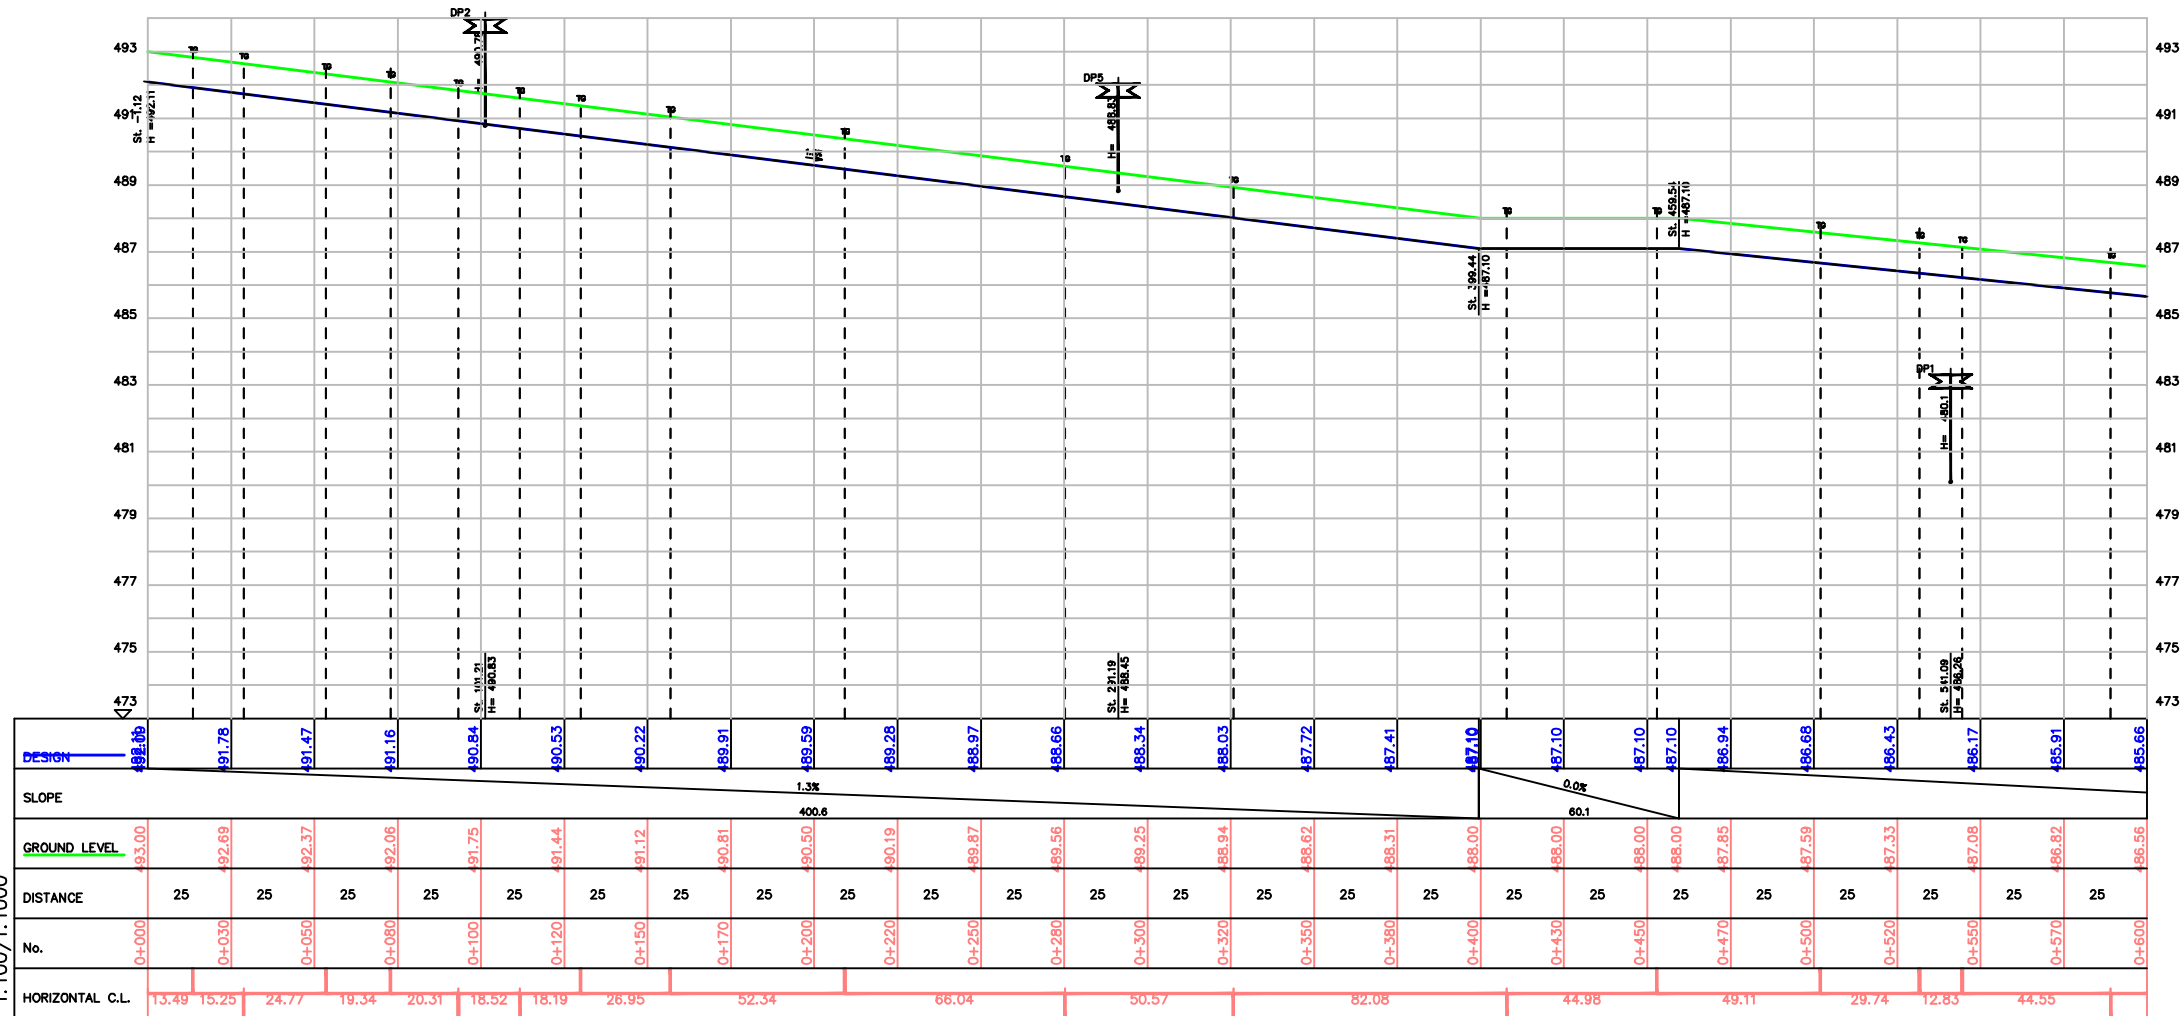

PROFILE


1:100/1:1000

		CLIENT:		USAID/MERCY CORPS		PROJECT		SMALL TOWN		DRAWING TITLE		Designed: Engr Soji		STAMP	
		CONSULTANT		KONSADEM ASSOCIATES LTD Engineers & Consultants 29, Okinbo Layout, P.M. S. 6476, Radeen, NIGERIA. E-mail: konsadem@gmail.com		ENGINEERING DESIGN OF WASH FACILITIES ACROSS BORNO, ADAMAWA AND YOBE (BAY) STATES Service Contract No: YOL SC 14		GANYE		DISTRIBUTION NETWORK PLAN AND PROFILE CH. 0+000 - 0+600.00		Drawn : Damola			
						STATE				DRAWING NO.		Checked : Engr Soji			
						ADAMAWA				BB/BD/O I		Date : MAY 2021			
Mark : Date :		Made by :		Revision						SCALE		Ref. No:		USAID/BAY/BU-00	

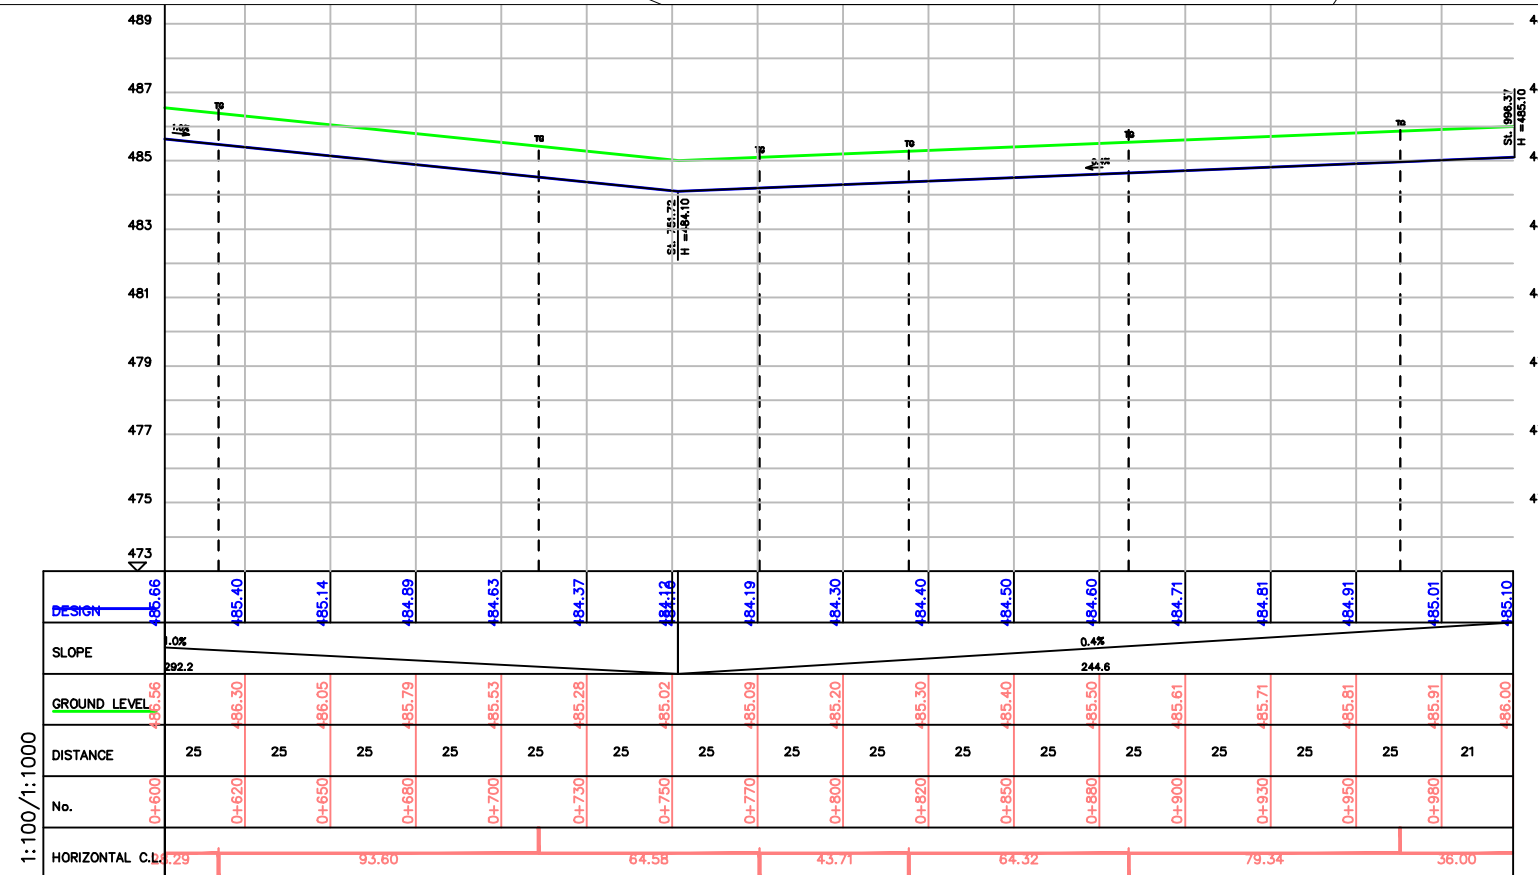


PROFILE

					CLIENT:	USAID/MERCY CORPS			PROJECT	SMALL TOWN	DRAWING TITLE		Designed: Engr Soy	STAMP
					CONSULTANT	 KONSADEM ASSOCIATES LTD Engineers & Consultants 30, Oshioke Layout, P.M. 8, 5478, Ibadan, NIGERIA. E-mail: konsadem@gmail.com	2ML CONSULTING NIGERIA LTD Office 8, 61-Clase Off 60(A) Road Gwerinpe Abide, 	ENGINEERING DESIGN OF WASH FACILITIES ACROSS BORNO, ADAMAWA AND YOBE (BAY) STATES Service Contract No: YOL SC 14	GANYE	DISTRIBUTION NETWORK PLAN AND PROFILE CH. 0+600 - 0+980.00		Drawn : Damola		
				STATE				ADAMAWA		DRAWING NO. BB/BD/O I	SCALE	Traced :		
				Mark : Date : Made by : Revision								Checked : Engr Soy		
												Date : MAY 2021	Ref. No: USAID/BAY/BU-00	

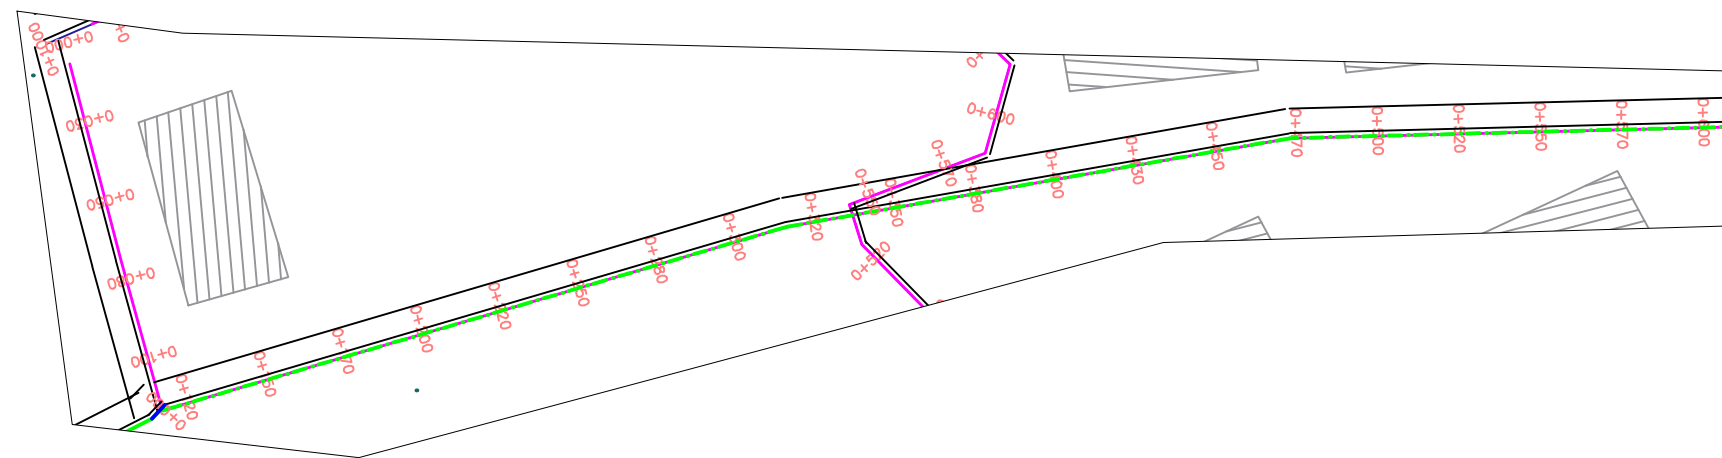


PLAN

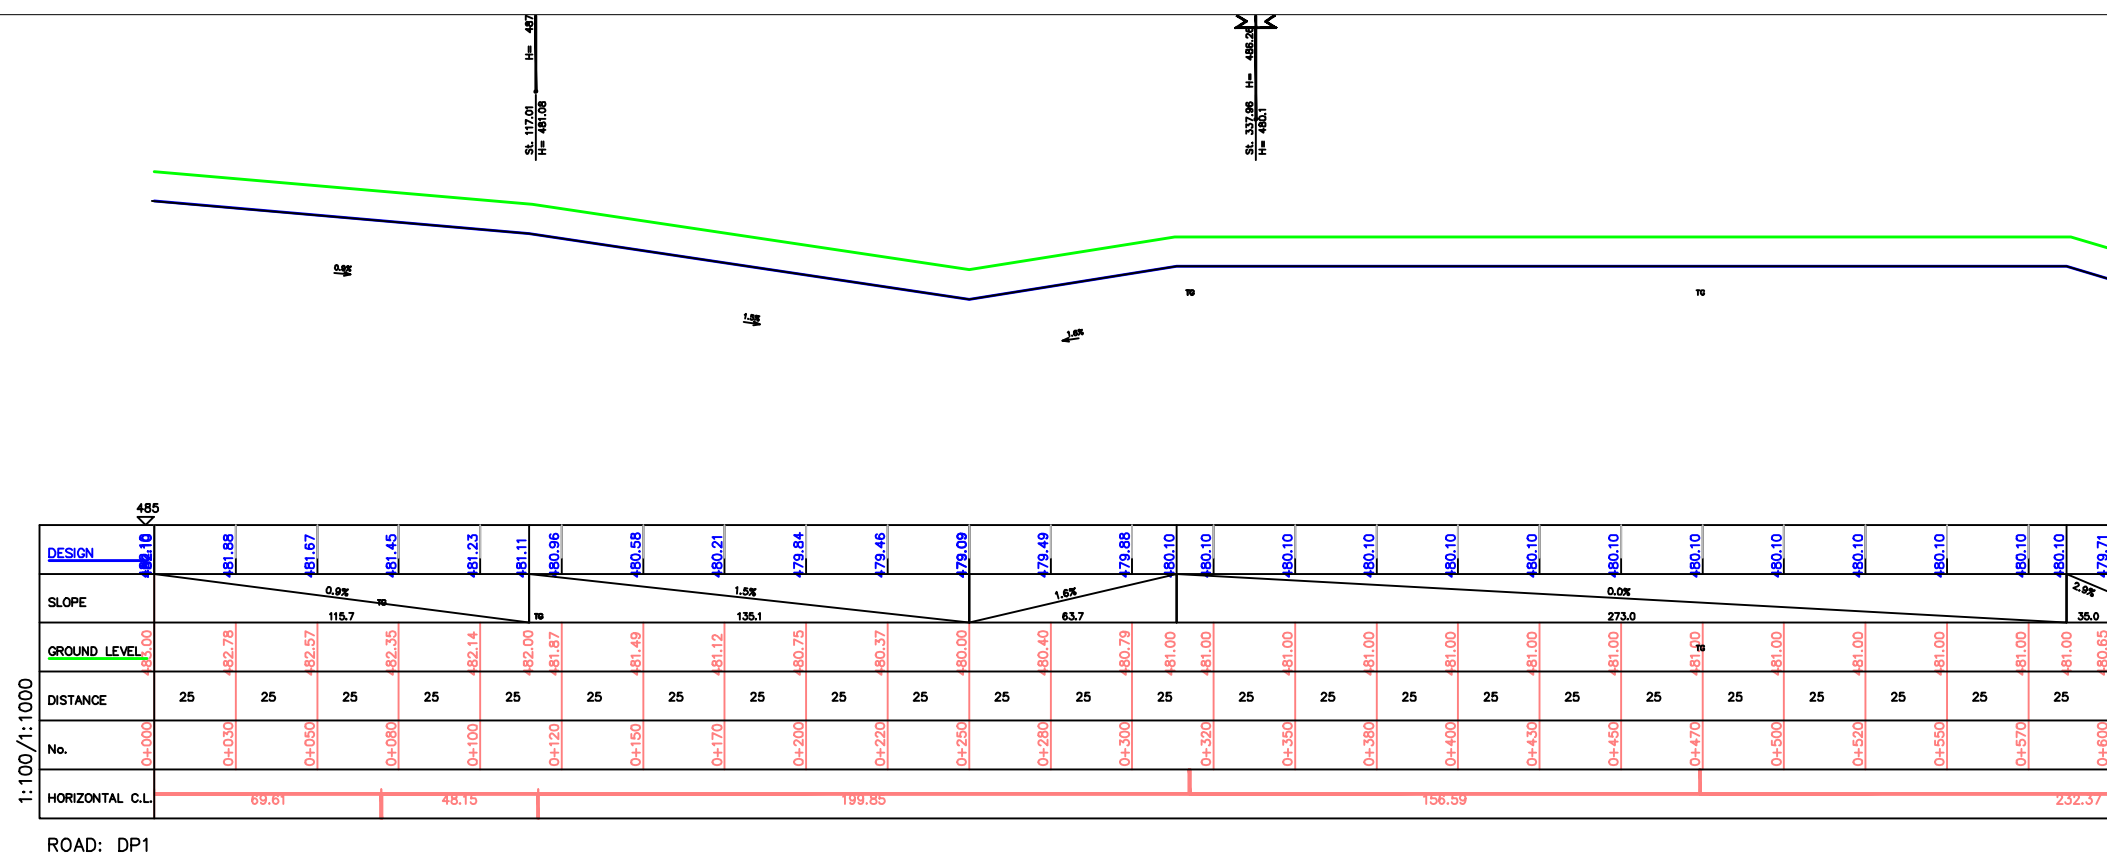

PROFILE

[illegible]

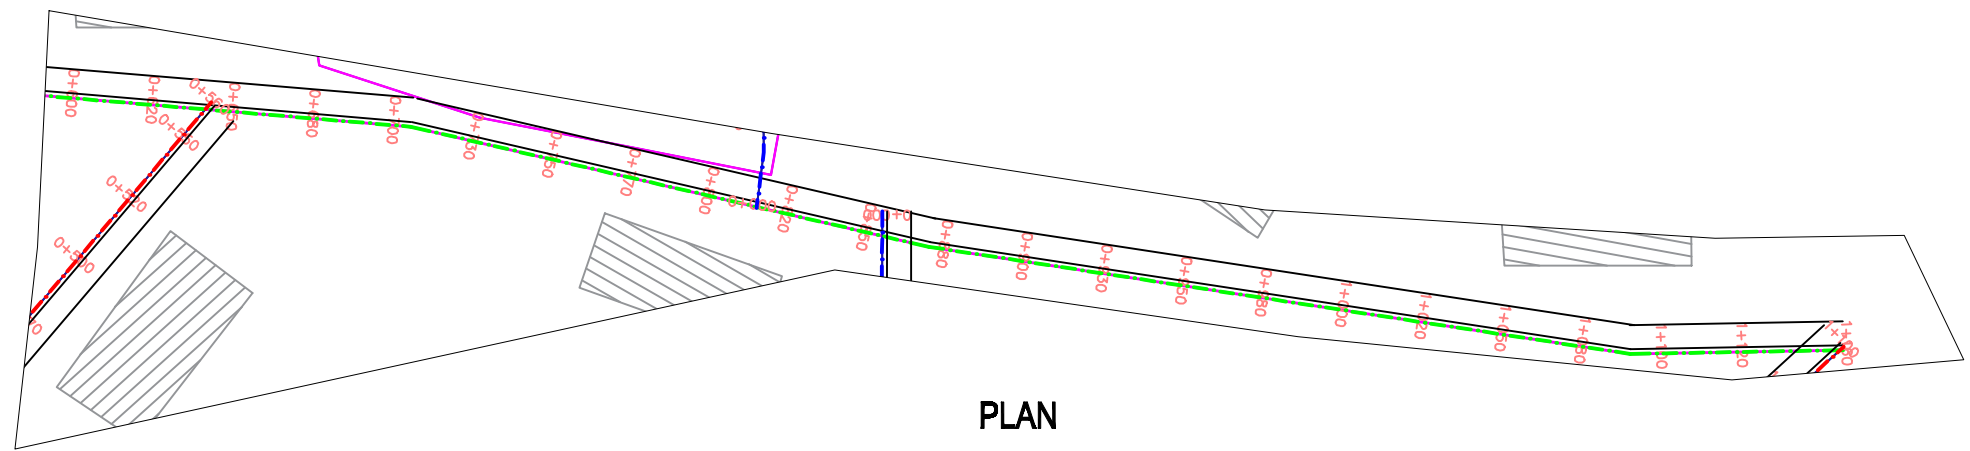



1:100/1:1000

DESIGN	SLOPE	GROUND LEVEL	DISTANCE	No.	HORIZONTAL C.L.
479.71	2.9%	483.65	25	0+600	164.92
479.07	35.0	480.07	25	0+620	
479.13	2.3%	480.65	25	0+650	219.88
479.73	43.8	481.00	25	0+680	
480.09	1.1%	480.89	25	0+700	68.15
479.98	175.0	480.60	25	0+730	
479.70	1.1%	480.32	25	0+750	
479.42	1.1%	480.04	25	0+770	
478.85	1.1%	479.76	25	0+800	
478.57	1.1%	479.47	25	0+820	
478.29	1.1%	479.19	25	0+850	
478.11	2.3%	478.82	25	0+880	
477.89	44.5	478.25	25	0+910	
477.53	0.0%	478.00	25	0+940	
477.10	0.0%	478.00	25	0+970	
477.10	0.0%	478.00	25	0+1000	
477.10	2.9%	477.74	25	0+1030	
476.80	33.4	477.00	25	0+1060	
476.13	1.3%	476.67	25	0+1090	
475.76	1.3%	476.33	25	0+1120	
475.43	1.3%	476.00	25	0+1150	
475.09	1.3%	475.67	25	0+1180	
474.76	1.3%	475.33	25	0+1210	
474.43	1.3%	475.00	25	0+1240	
474.11	1.3%	474.67	25	0+1270	


ROAD: DP1

PROFILE


				CLIENT: USAID/MERCY CORPS CONSULTANT KONSADM ASSOCIATES LTD Engineers & Consultants 20, Oronia Layout, P.M.B. 5478, Ibadan, NIGERIA. E-mail: konsadem@gmail.com 2ML CONSULTING NIGERIA LTD Office 8, 85-Class Off 68(A) Road Gwarinpa Abuja,	PROJECT ENGINEERING DESIGN OF WASH FACILITIES ACROSS BORNO, ADAMAWA AND YOBE (BAY) STATES <i>Service Contract No: YOL SC 14</i> STATE ADAMAWA	SMALL TOWN GANYE	DRAWING TITLE DISTRIBUTION NETWORK PLAN AND PROFILE: DP ROAD 1 CH. 0+600 - 1+150.00 DRAWING NO. BB/BD/O 1	SCALE	Designed: Engr Soji Drawn : Damola Traced : Checked : Engr Soji Date : MAY 2021 Ref. No: USAID/BAY/BU-00	STAMP
Mark :	Date :	Made by :	Revision							

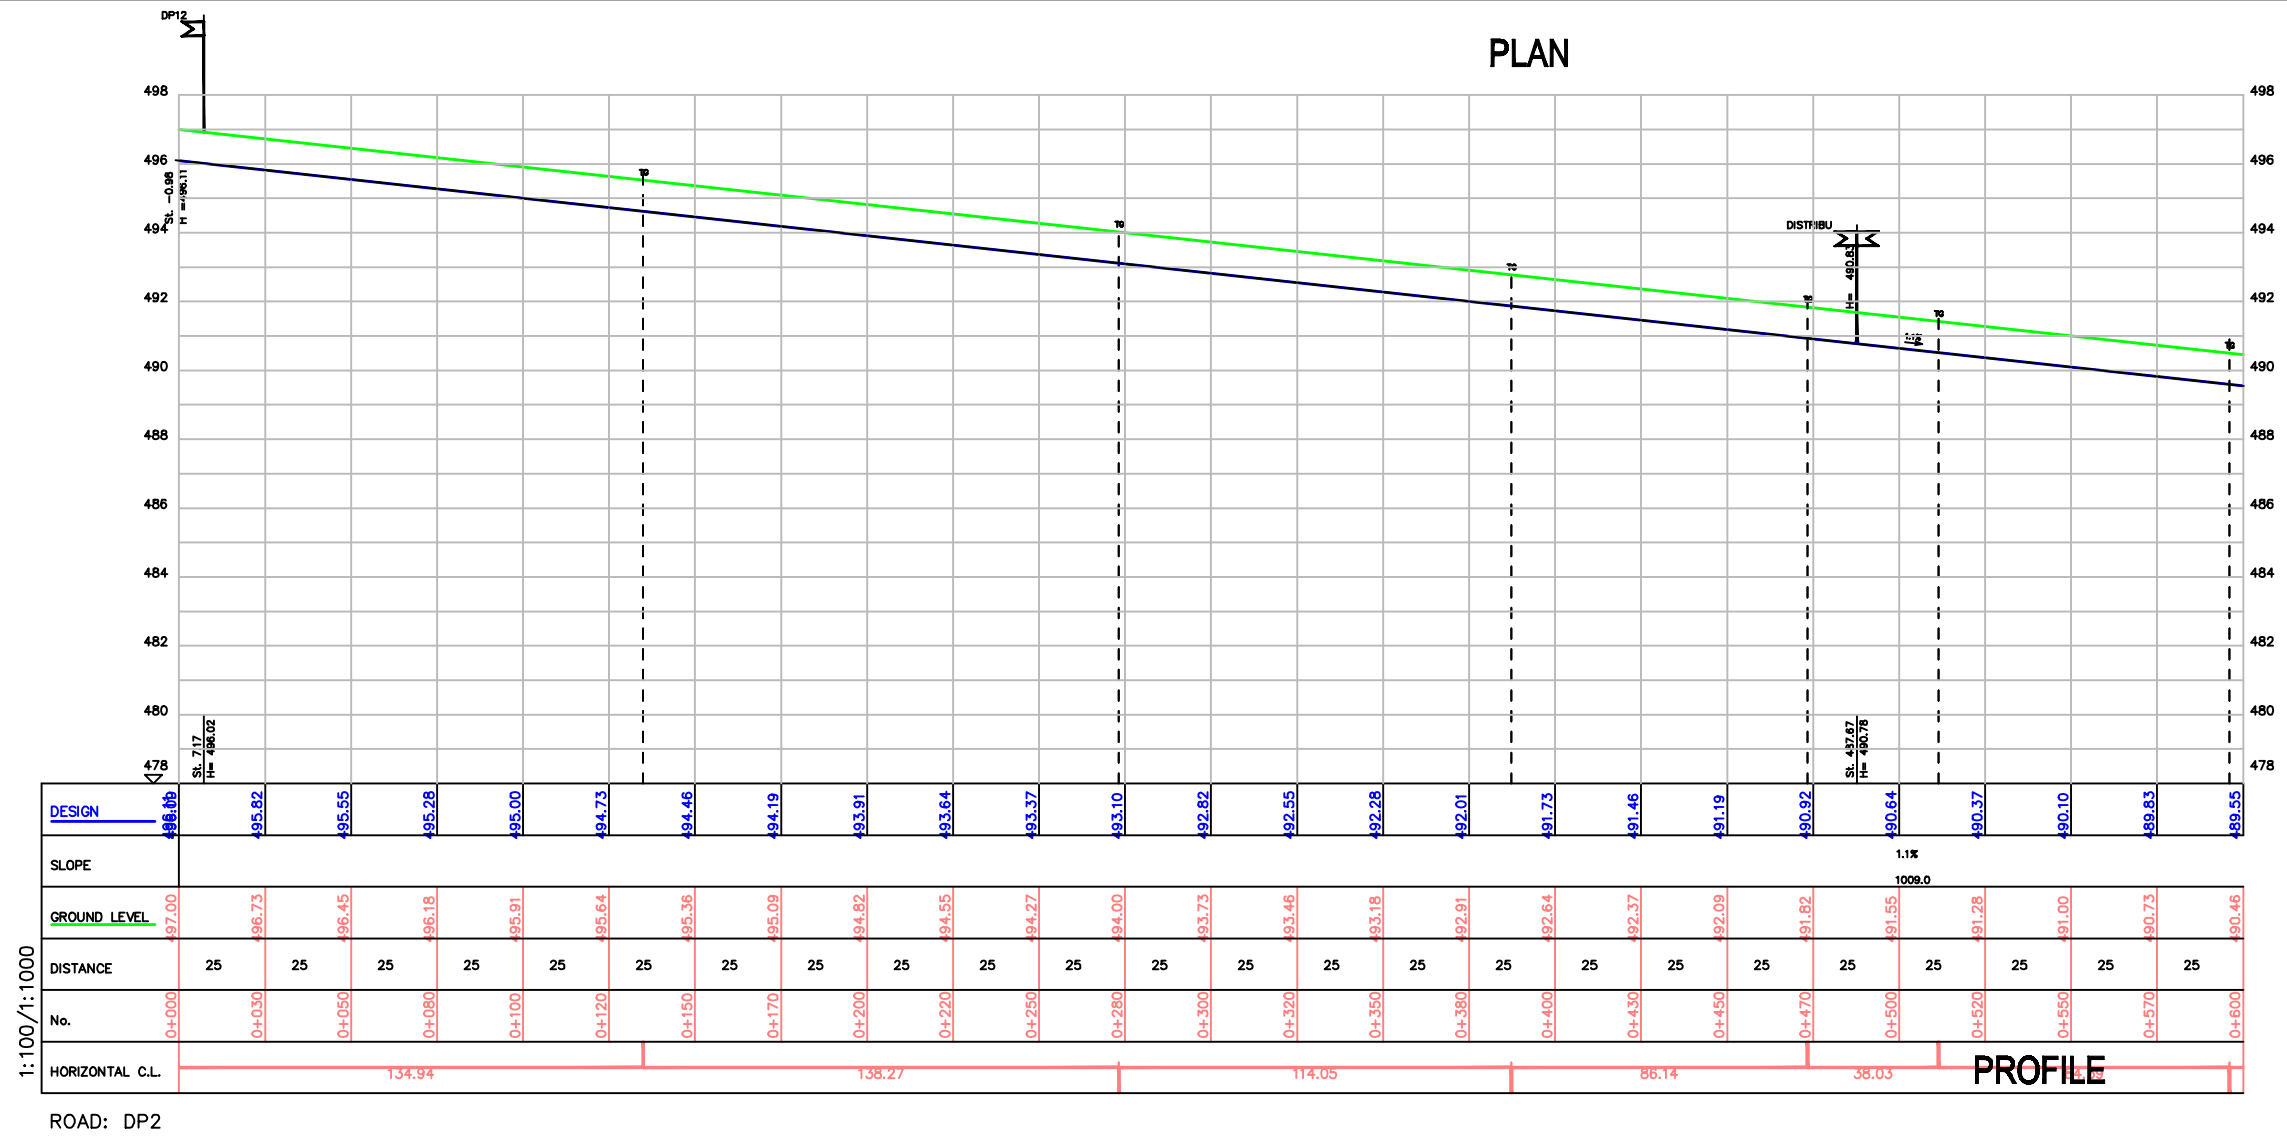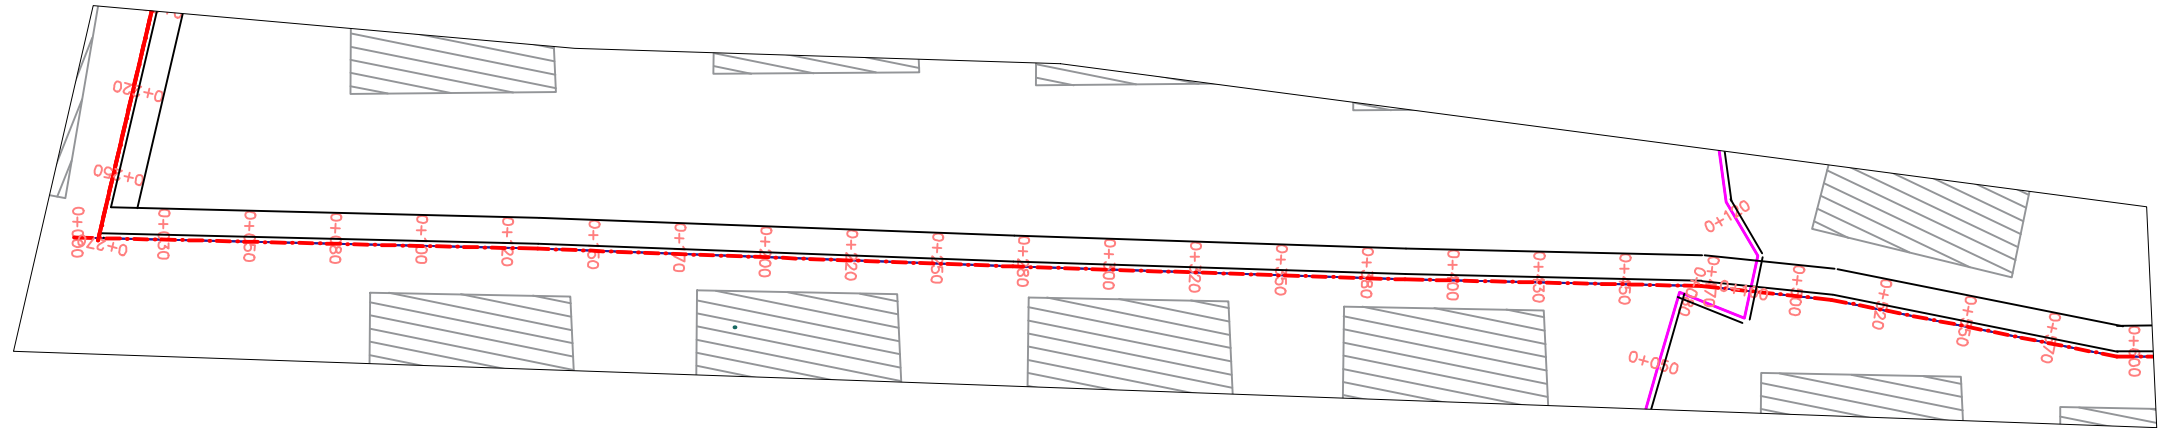

Mark : Date : Made by : Revision	CLIENT:	USAID/MERCY CORPS		PROJECT	SMALL TOWN	DRAWING TITLE	Designed: Engr. Soji	STAMP
	CONSULTANT	KONSADEM ASSOCIATES LTD Engineers & Consultants 30, Onitsha Layout, P.M. S. 8478, Ibadan, NIGERIA. E-mail: konsadem@gmail.com		ENGINEERING DESIGN OF WASH FACILITIES ACROSS BORNO, ADAMAWA AND YOBE (BAY) STATES Service Contract No: YOL SC 14		DISTRIBUTION NETWORK PLAN AND PROFILE: DP ROAD 2 CH. 0+000 - 0+600.00	Drawn : Damola	
		2ML CONSULTING NIGERIA LTD Office 8, 81-Close Off 89(A) Road Gwarimpa Abuja,		ADAMAWA	BB/BD/O I	Checked : Engr. Soji		
						Date : MAY 2021		
						Ref. No:	USAID/BAY/BU-00	

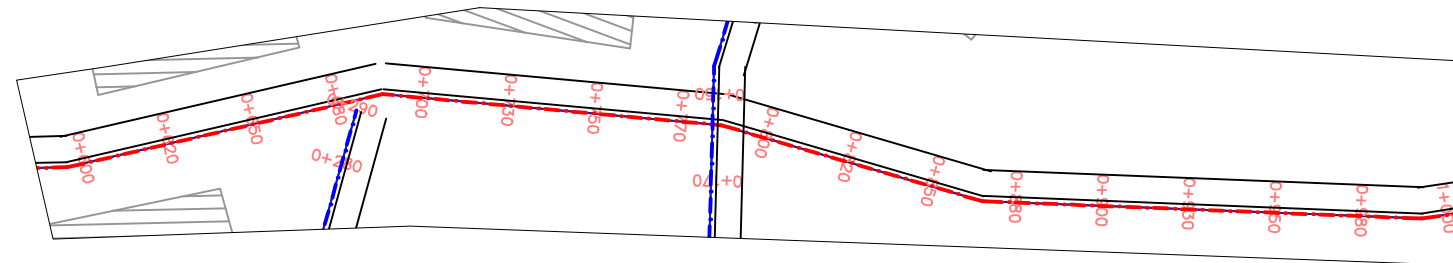


PLAN

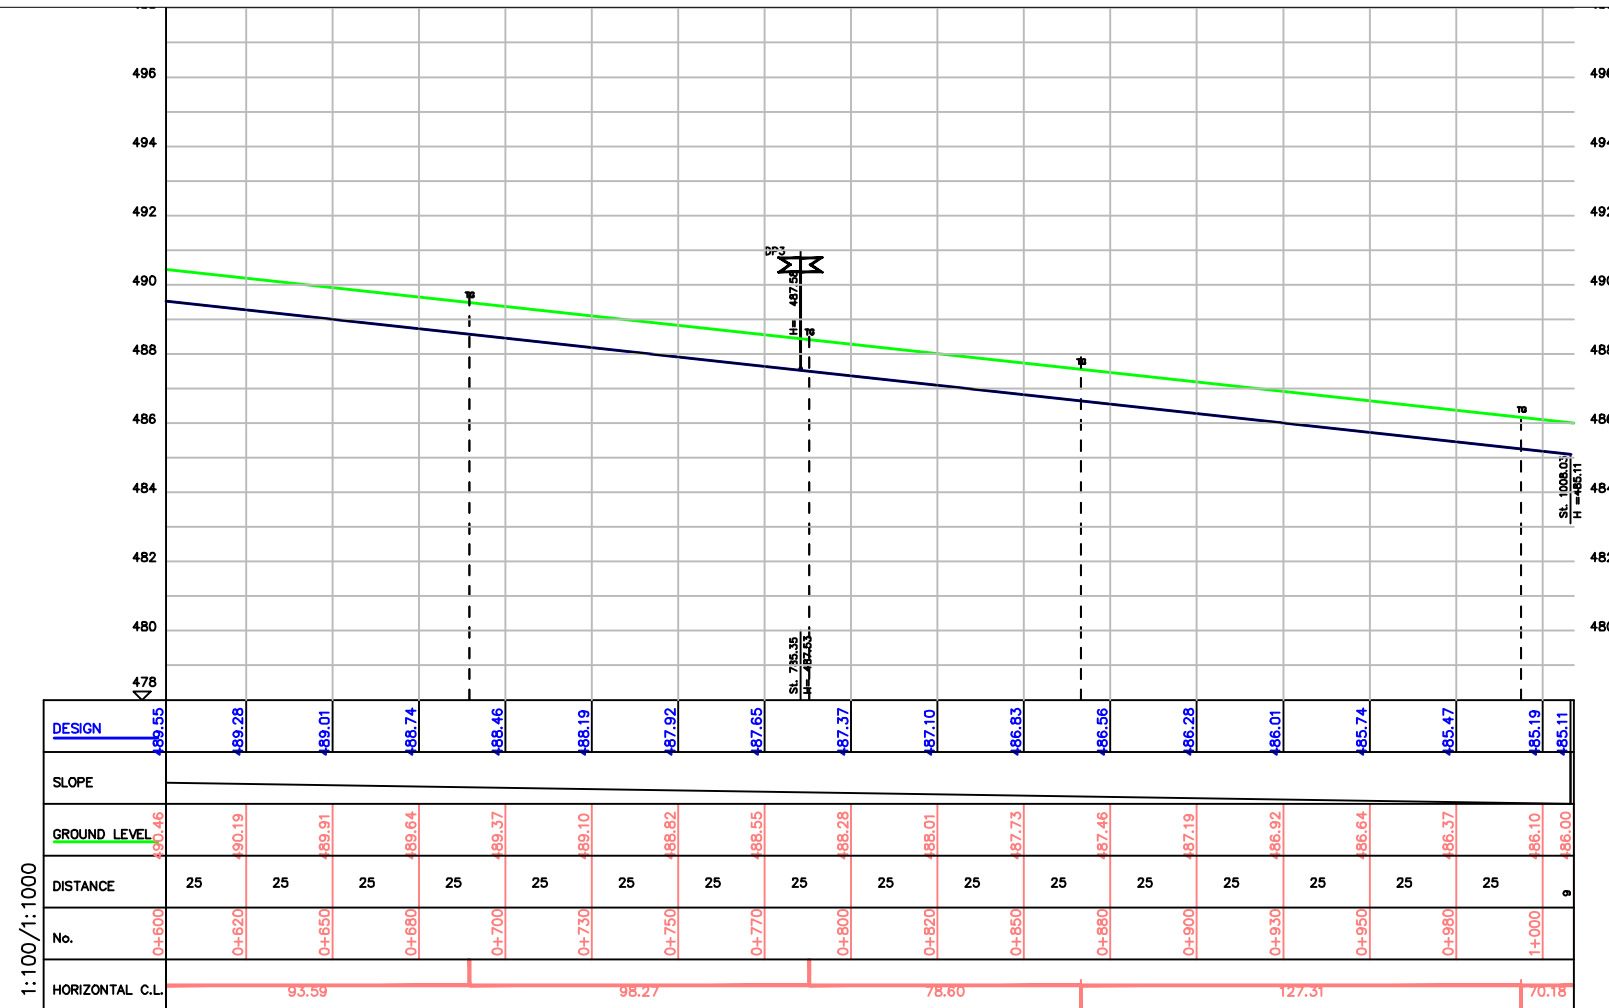


PROFILE

				CLIENT:	USAID/MERCY CORPS	PROJECT	ENGINEERING DESIGN OF WASH FACILITIES ACROSS BORNO, ADAMAWA AND YOBE (BAY) STATES	SMALL TOWN	GANYE	DRAWING TITLE	DISTRIBUTION NETWORK PLAN AND PROFILE: DP ROAD 2 CH. 0+600 - 1+000.00	Designed:	Engr Sgy	STAMP
				CONSULTANT	KONSADM ASSOCIATES LTD Engineers & Consultants 30, Onitoke Layout, P.M. B. 6476, Ibadan, NIGERIA E-mail: konsadem@gmail.com	2ML CONSULTING NIGERIA LTD Office 8, S1-Close Off 60(A) Road Gwerinpa Abide.	STATE	ADAMAWA		DRAWING NO.	BB/BD/01	Drawn :	Damola	
Mark :	Date :	Made by :	Revision							SCALE		Traced :	Engr Sgy	
												Checked :	MAY 2021	
												Date :		
												Ref. No:	USAID/BAY/BU-00	

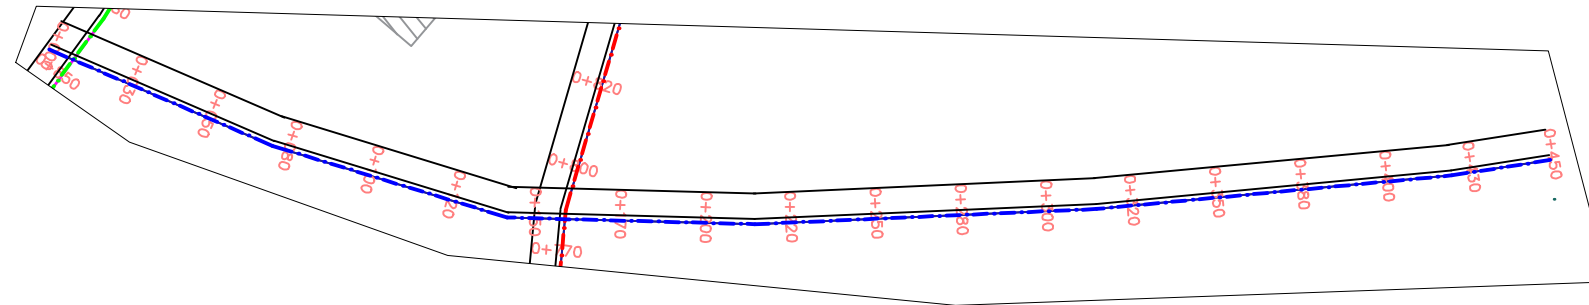

PLAN

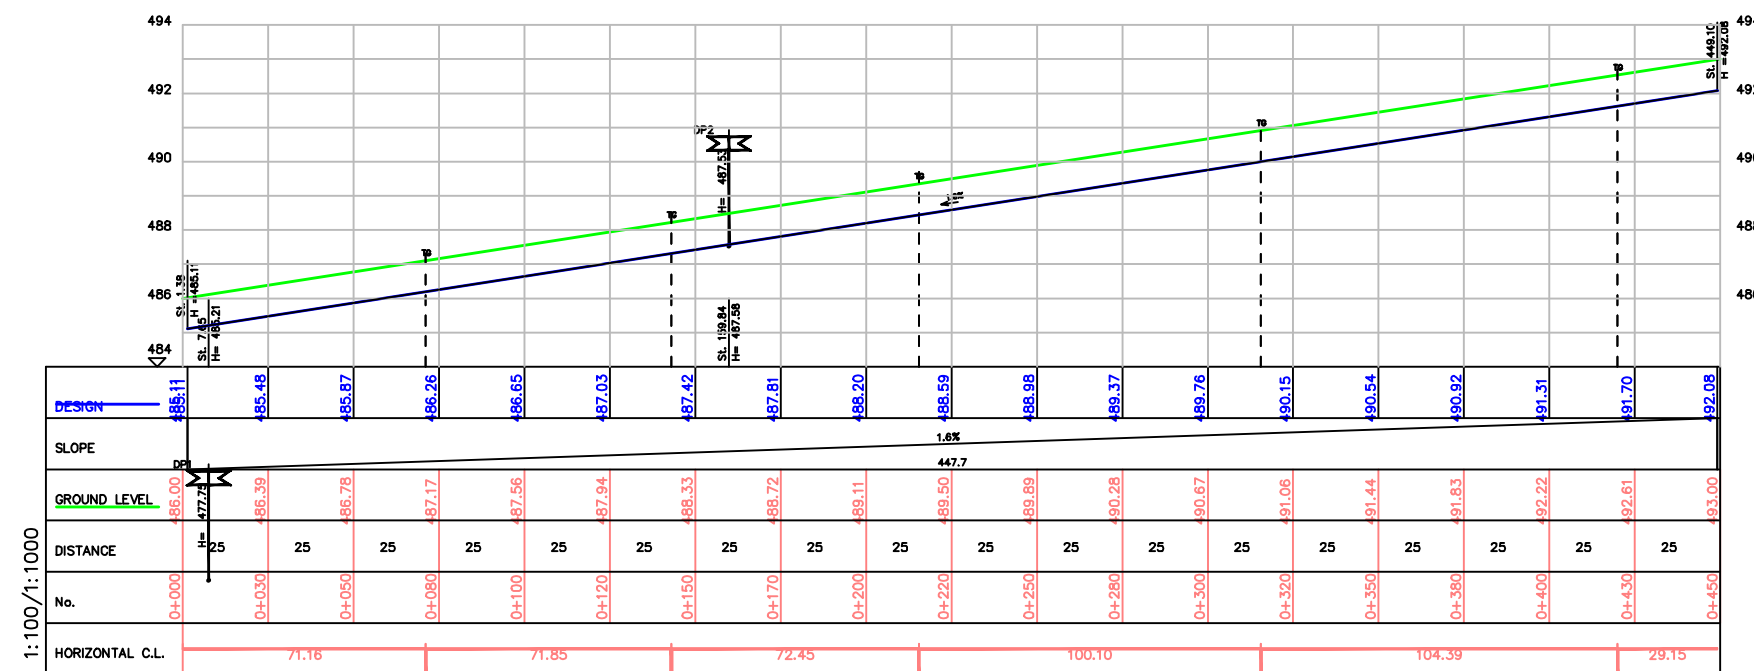

ROAD: DP3

PROFILE

				CLIENT: USAID/MERCY CORPS				PROJECT ENGINEERING DESIGN OF WASH FACILITIES ACROSS BORNO, ADAMAWA AND YOBE (BAY) STATES Service Contract No: YOL SC 14				SMALL TOWN GANYE		DRAWING TITLE DISTRIBUTION NETWORK PLAN AND PROFILE: DP ROAD 3 CH. 0+000 - 0+450.00		Designed: Engr Soji Drawn : Damola Traced : Checked : Engr Soji Date : MAY 2021		STAMP	
				CONSULTANT KONSADEM ASSOCIATES LTD Engineers & Consultants 36, Onireke Layout, P.M. B. 8476, Ibadan, NIGERIA. E-mail: konsadem@gmail.com				2ML CONSULTING NIGERIA LTD Office 8, 83-Clase Off 80(A) Road Gwarimpa Abuja.						DRAWING NO. BB/BD/O I		SCALE		Ref. No: USAID/BAY/BU-00	
Mark : Date : Made by : Revision								STATE ADAMAWA											